
 


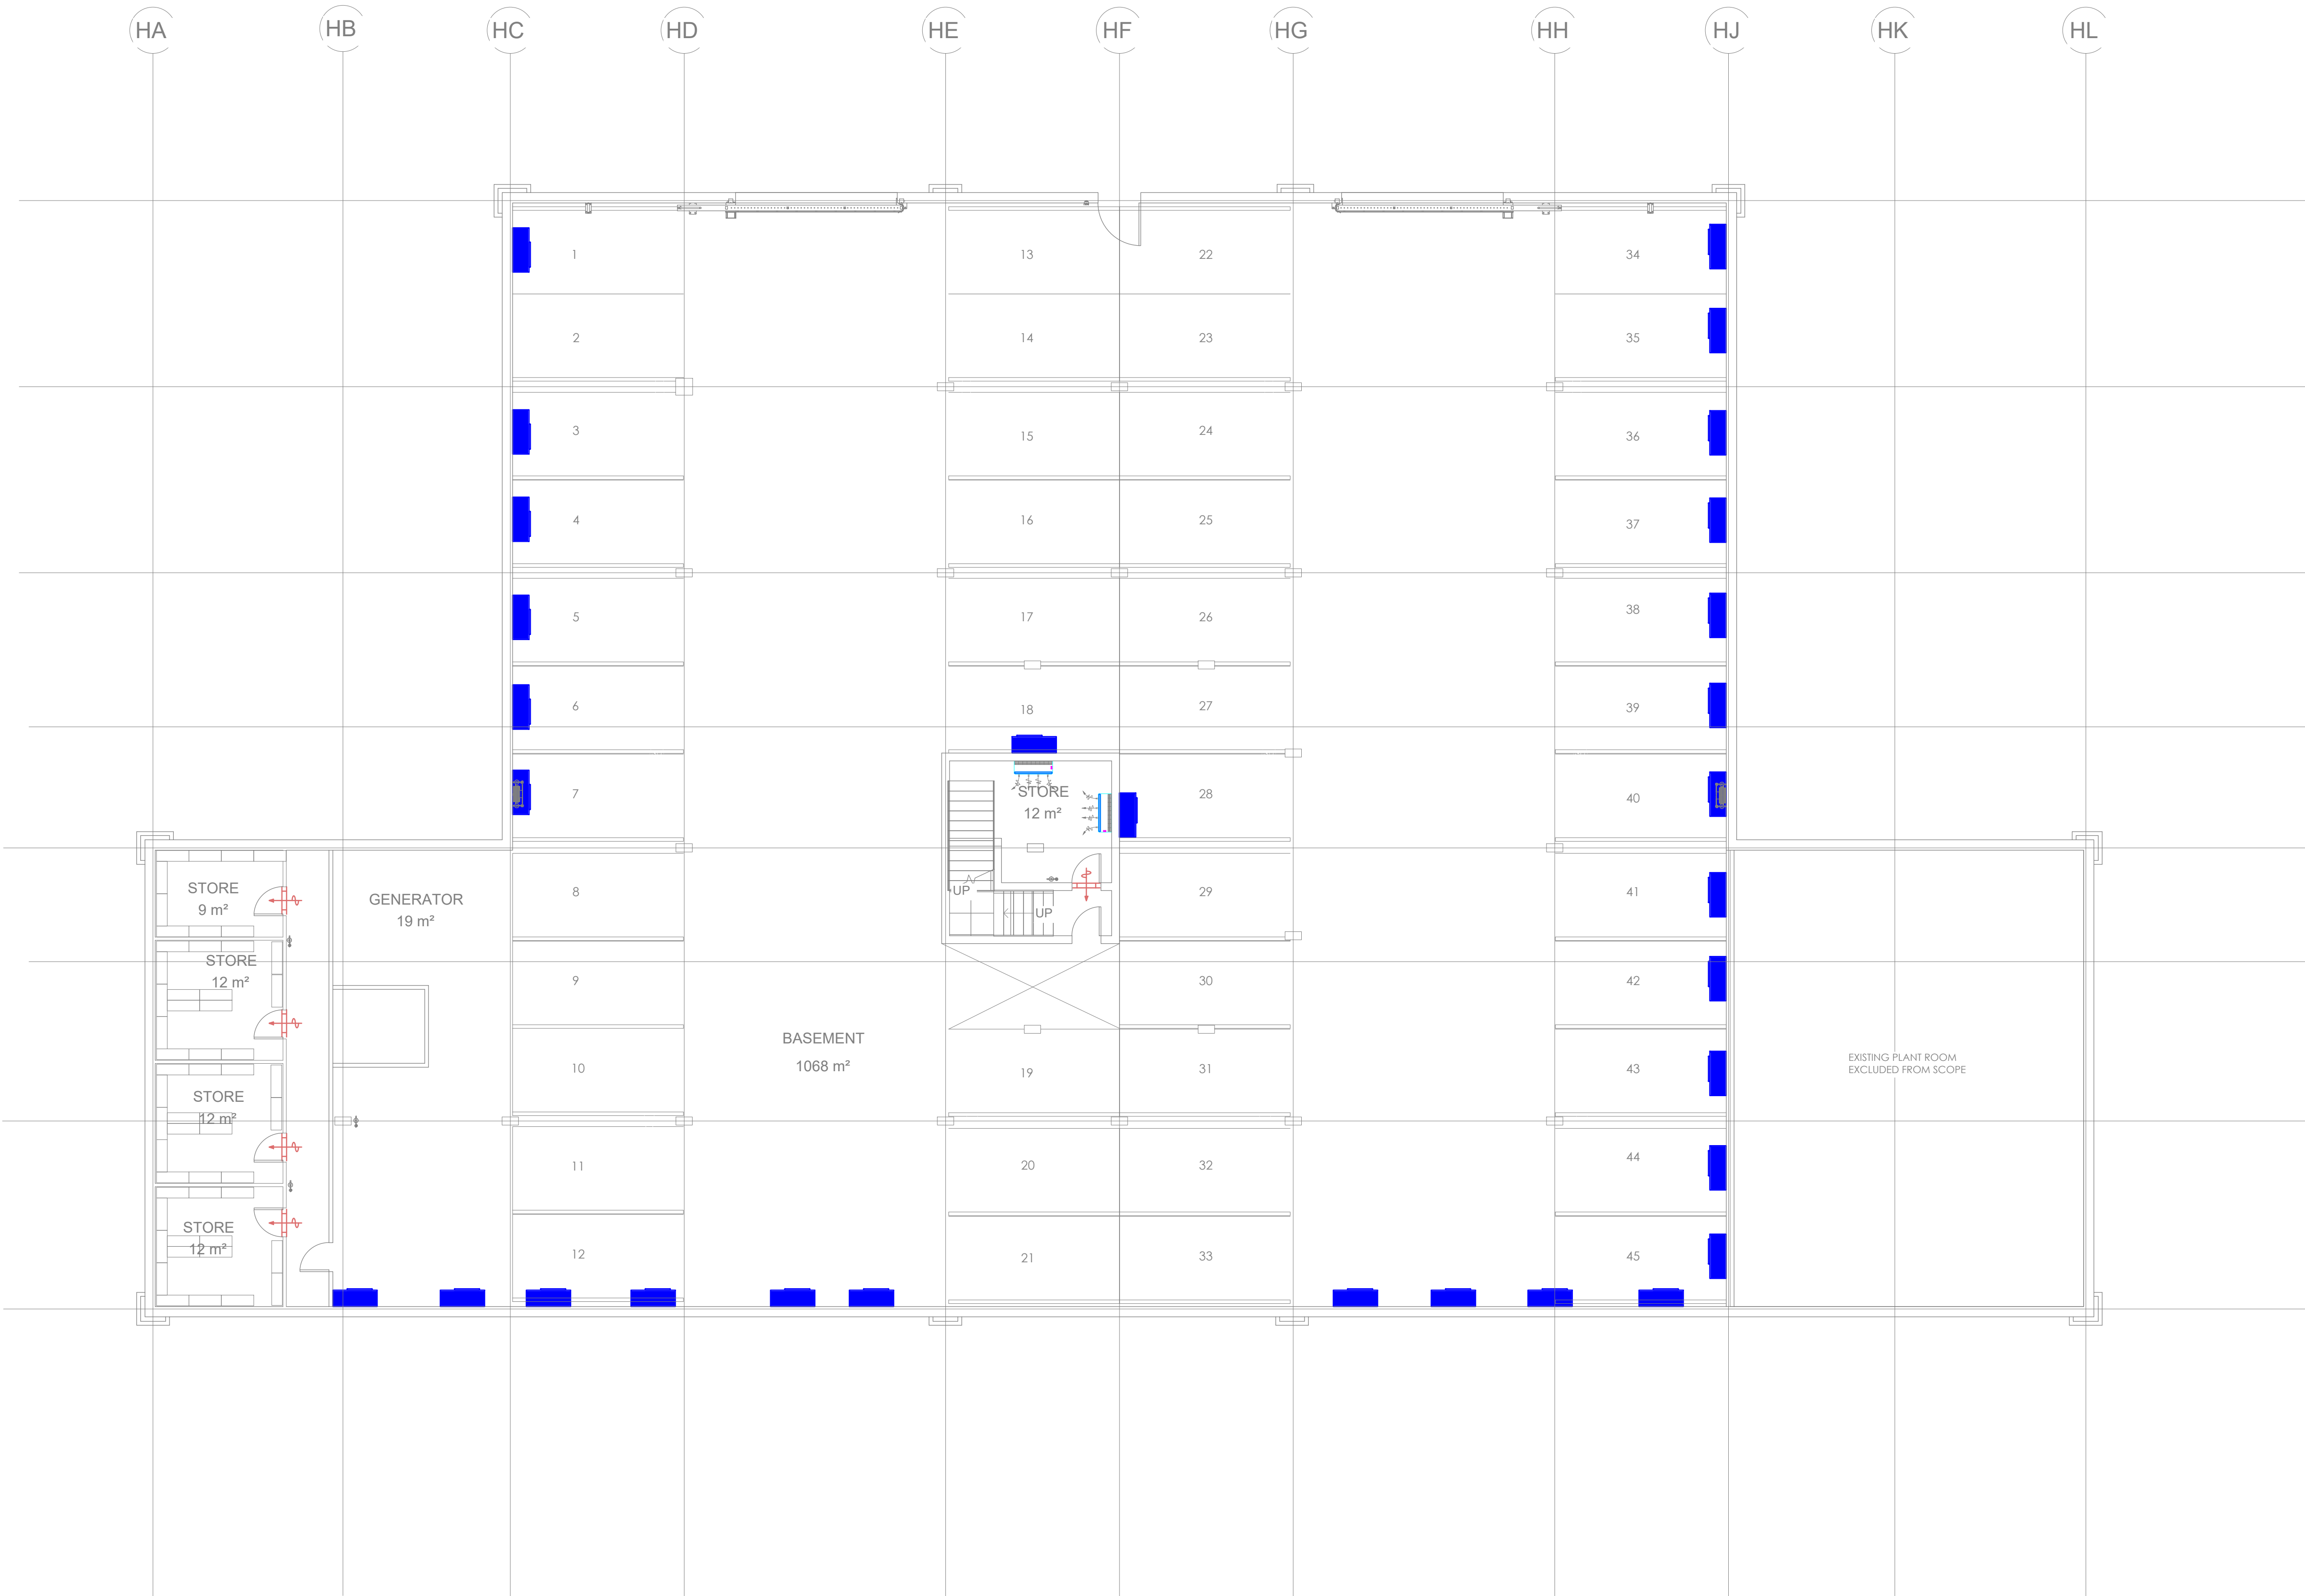

LEGEND

AC EQUIPMENT

 
CASSETTE SPLIT UNIT




HIDE AWAY SPLIT UNIT



HIGH WALL SPLIT UNIT



DIFFUSER

 

EXTRACTION VALVE



DUCT MOUNTED FAN

 


DOOR GRILLE



PIPING

REFRIGERATION PIPING



DRAINAGE PIPING



NOTES:

1. THIS DRAWING IS TO BE READ IN CONJUNCTION WITH ALL RELEVANT ARCHITECTS AND ENGINEERS DRAWINGS.
2. COPYRIGHT OF THIS DRAWING IS VESTED IN THE CONSULTING ENGINEERING COMPANY
3. CONTRACTOR TO CHECK DRAWING AND REPORT ANY DISCREPANCIES TO THE ENGINEER BEFORE MATERIALS ARE ORDERED AND EXECUTED ON SITE.
4. DO NOT SCALE FROM THIS DRAWING. THE CONTRACTOR IS TO CHECK AND CONFIRM ALL DIMENSIONS ON SITE.
5. THE CONTRACTOR TO SUBMIT COORDINATED SHOP DRAWINGS FOR APPROVAL BEFORE THEY CARRY OUT ANY WORK ON SITE.

T	ISSUED FOR TENDER		27/08/25
REV	REVISION DETAILS		DATE

CLIENT

ARCHITECT

CONSULTING ENGINEERS

Gauteng Office:	Suite 13, Rivonia Gate, 381 Rivonia Boulevard, Rivonia, Sandton, 2191 Tel: 010 500 1486 www.henryfagan.com
Western Cape Office:	Suite A2, Ground Floor Building 2, Nordic Park 2, 17 Boundary Road, Century City, 7441 Tel: 021 423 0873 www.henryfagan.com

PROJECT

MHS OFFICE
BUILDING RENOVATION

DRAWING TITLE

BASEMENT FLOOR
HVAC LAYOUT

DRAWN BY	DESIGNED BY	CHECKED BY
T.L	T.M	R.R
SCALE	DATE	SHEET SIZE
1:100	01 JULY 2025	A1

PROJECT - ORIG - ZONE - LEVEL - TYPE - DISC - CLASS - NUMBER - REVISION

25002 - HF - ZZ - L0 - DR-ME- DD - 1000 - T