
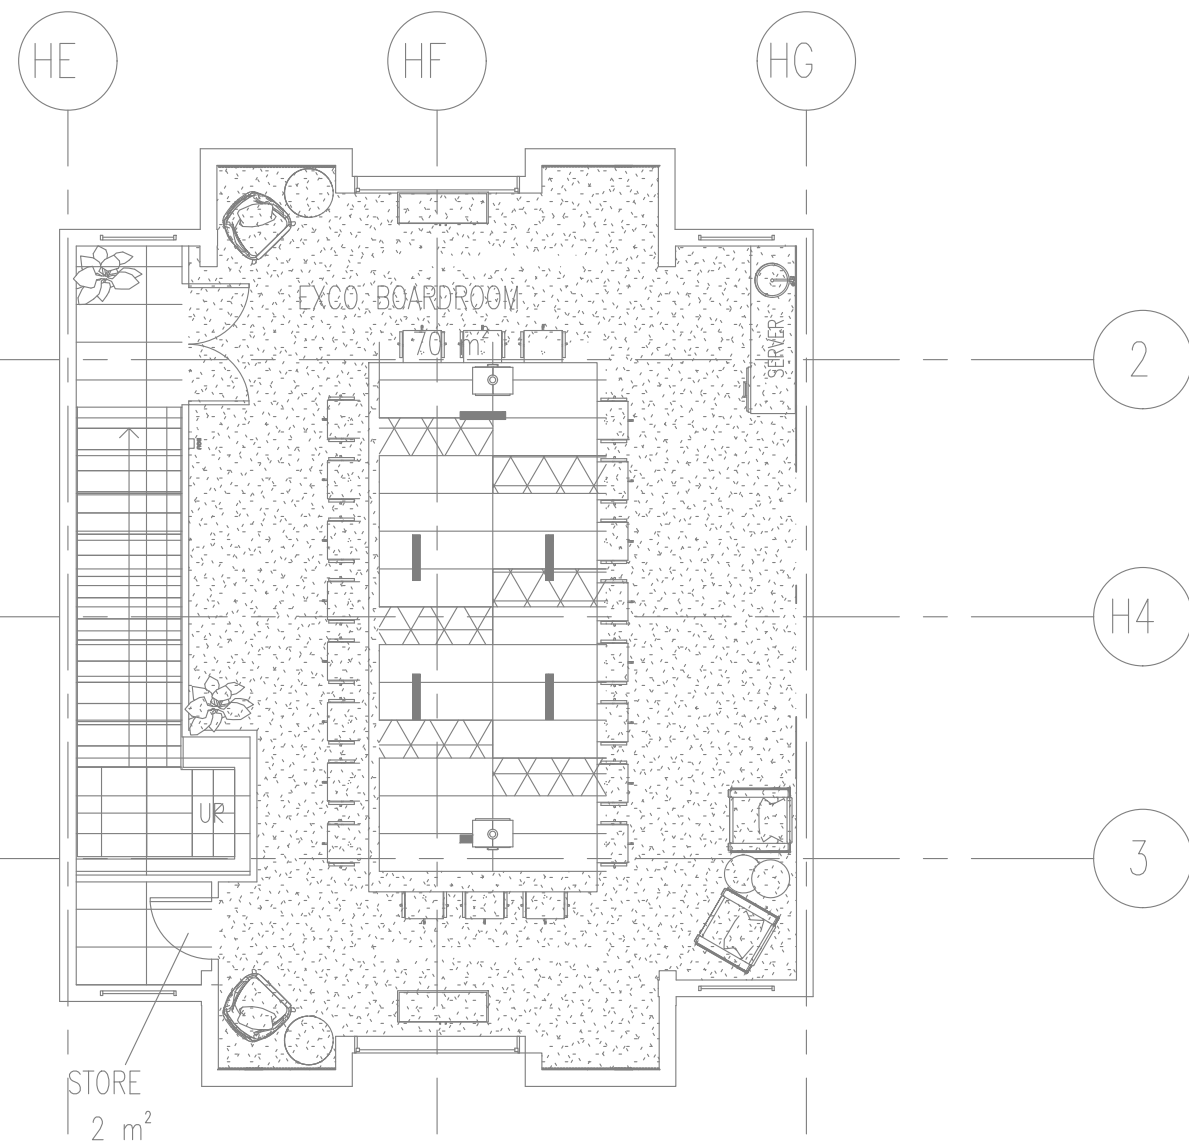


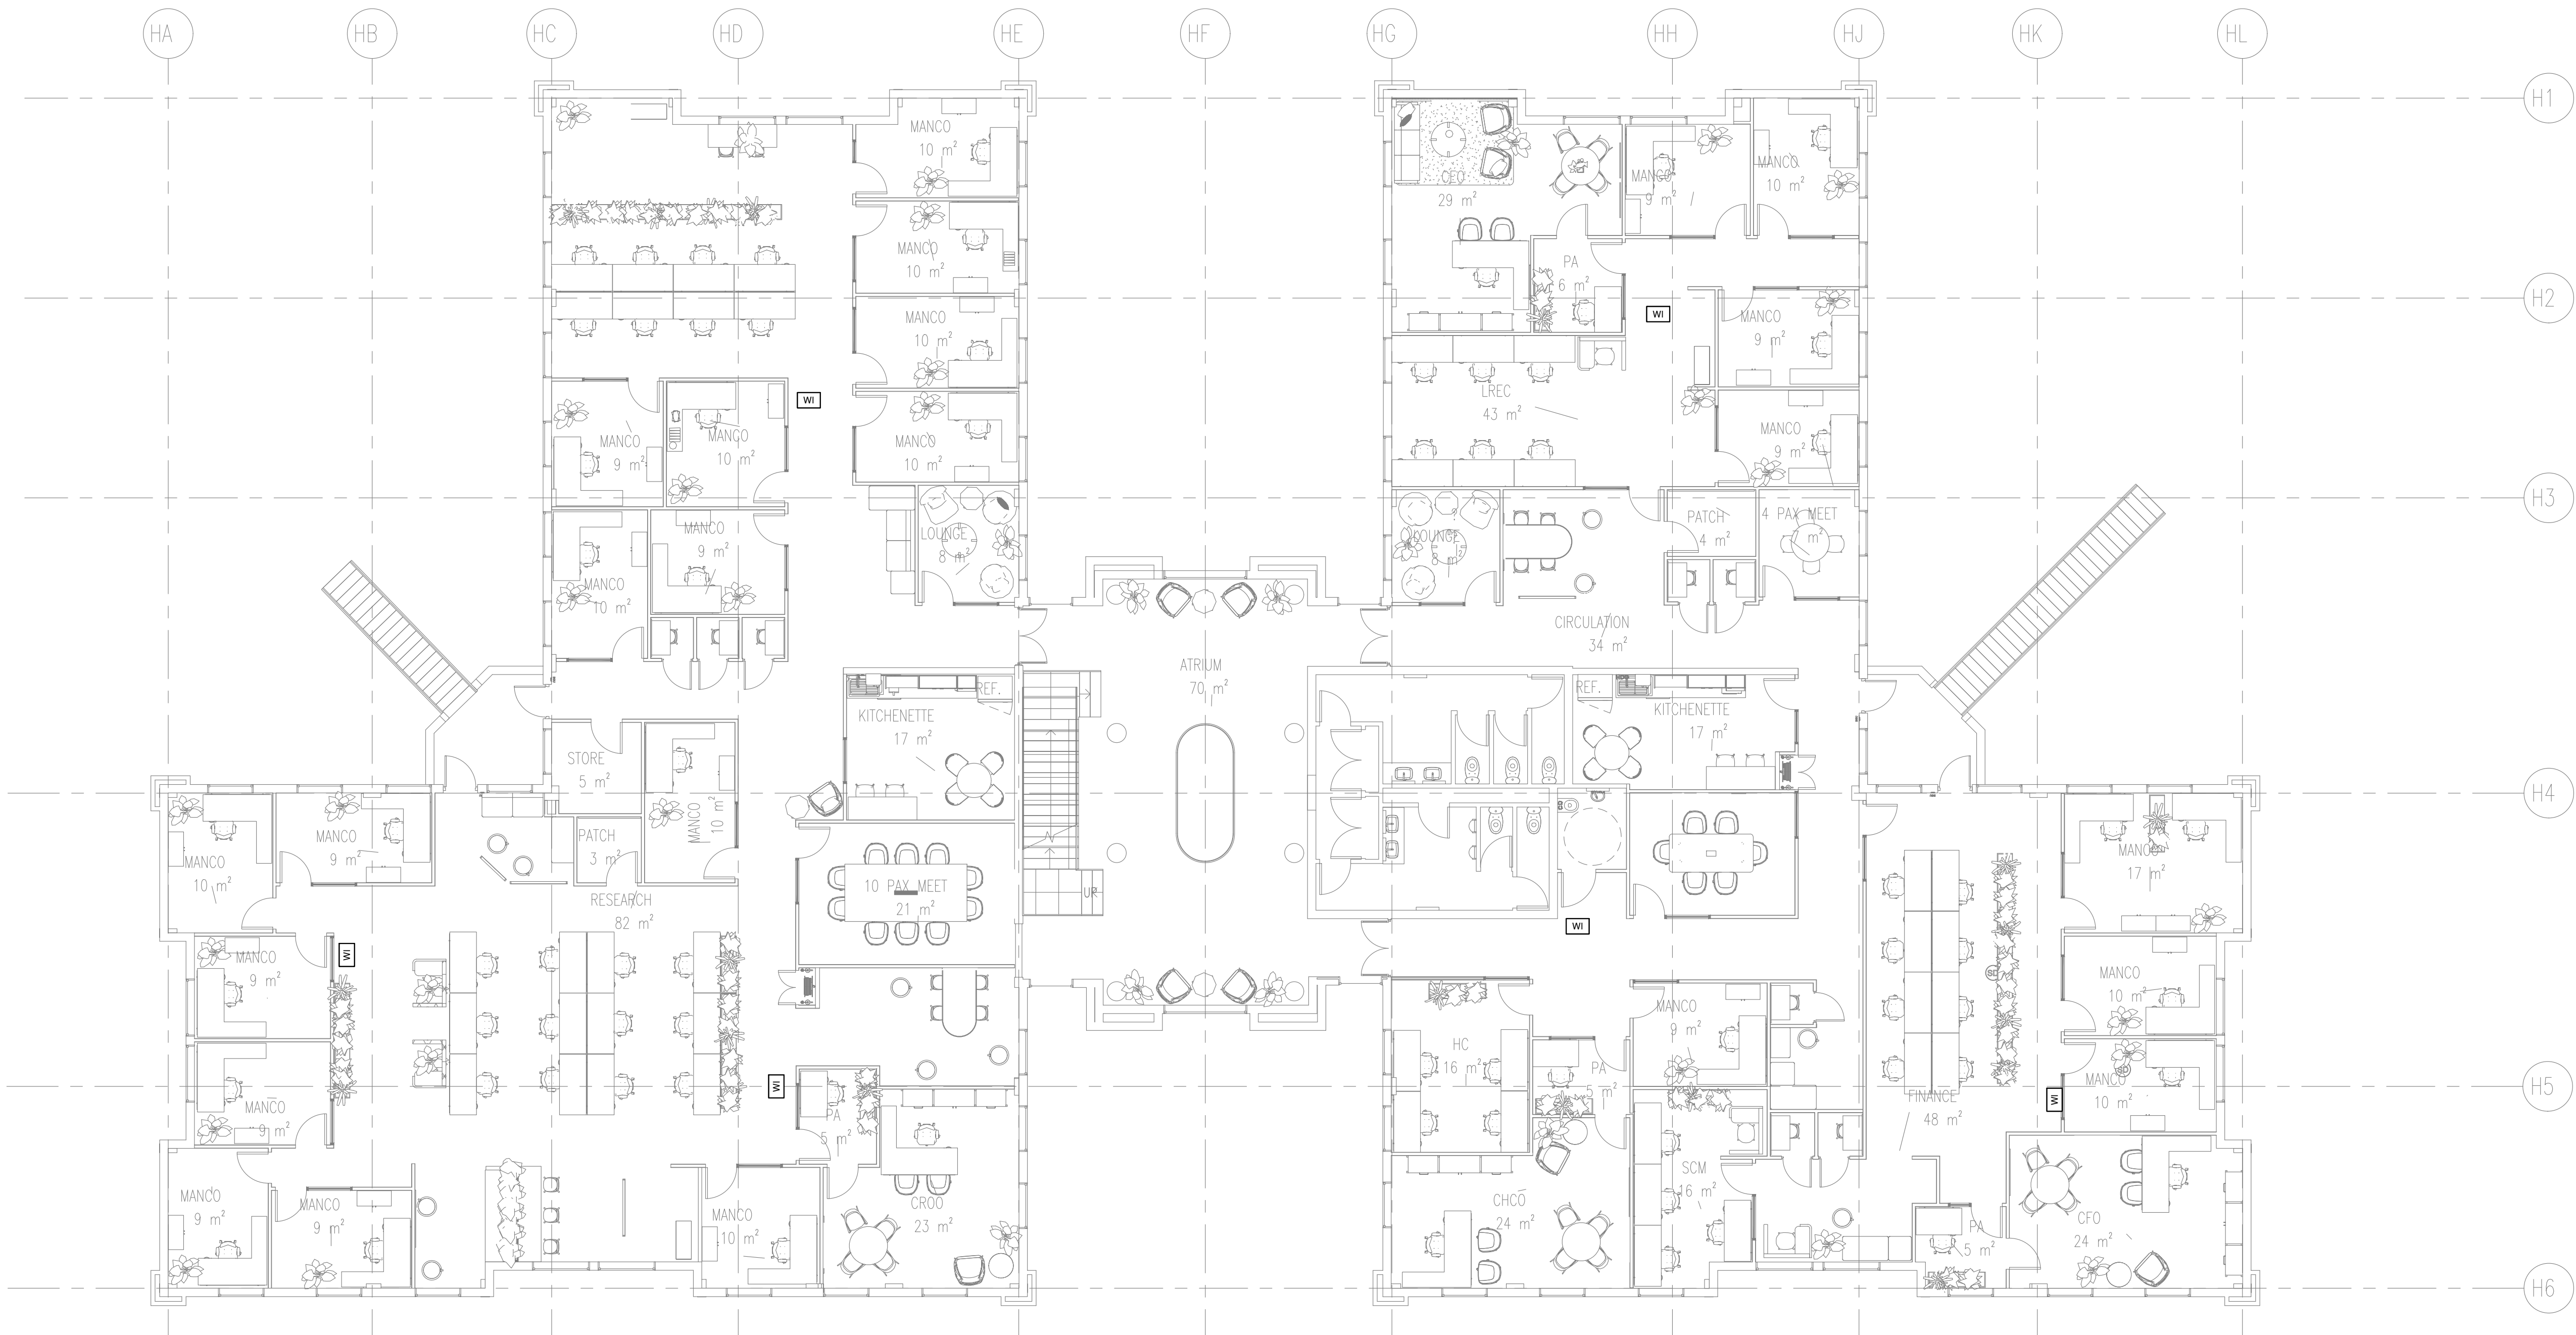

LEGEND

WI

WIFI OUTLET

ISSUED FOR TENDER

T	ISSUED FOR TENDER	29.08.2025
REV	REVISION DETAILS	DATE

CLIENT

MHSC
Mine Health and Safety Council

ARCHITECT

CONSULTING ENGINEERS

HENRY FAGAN
Consulting Engineers & Project Managers

Gauteng Office: Suite 13, Rivonia Gate, 381 Rivonia Boulevard, Rivonia, Sandton, 2191
Tel: 010 500 1486
www.henryfagan.com
Western Cape Office: Suite A2, Ground Floor Building 2, Nordic Park 2, 17 Boundary Road, Century City, 7441
Tel: 021 423 0873
www.henryfagan.com

PROJECT
MHSC OFFICE
BUILDING RENOVATION

DRAWING TITLE
UPPER GROUND
DATA LAYOUT

DRAWN BY	DESIGNED BY	CHECKED BY
B.T	P.M	M.B
SCALE	DATE	SHEET SIZE
1:100	01 JULY 2025	A1

PROJECT - **ORIG** - **ZONE** - **LEVEL** - **TYPE** - **DISC** - **CLASS** - **NUMBER** - **REVISION**
25002 - HF - ZZ - L1 - DR-EE- DD - 1002 - T