


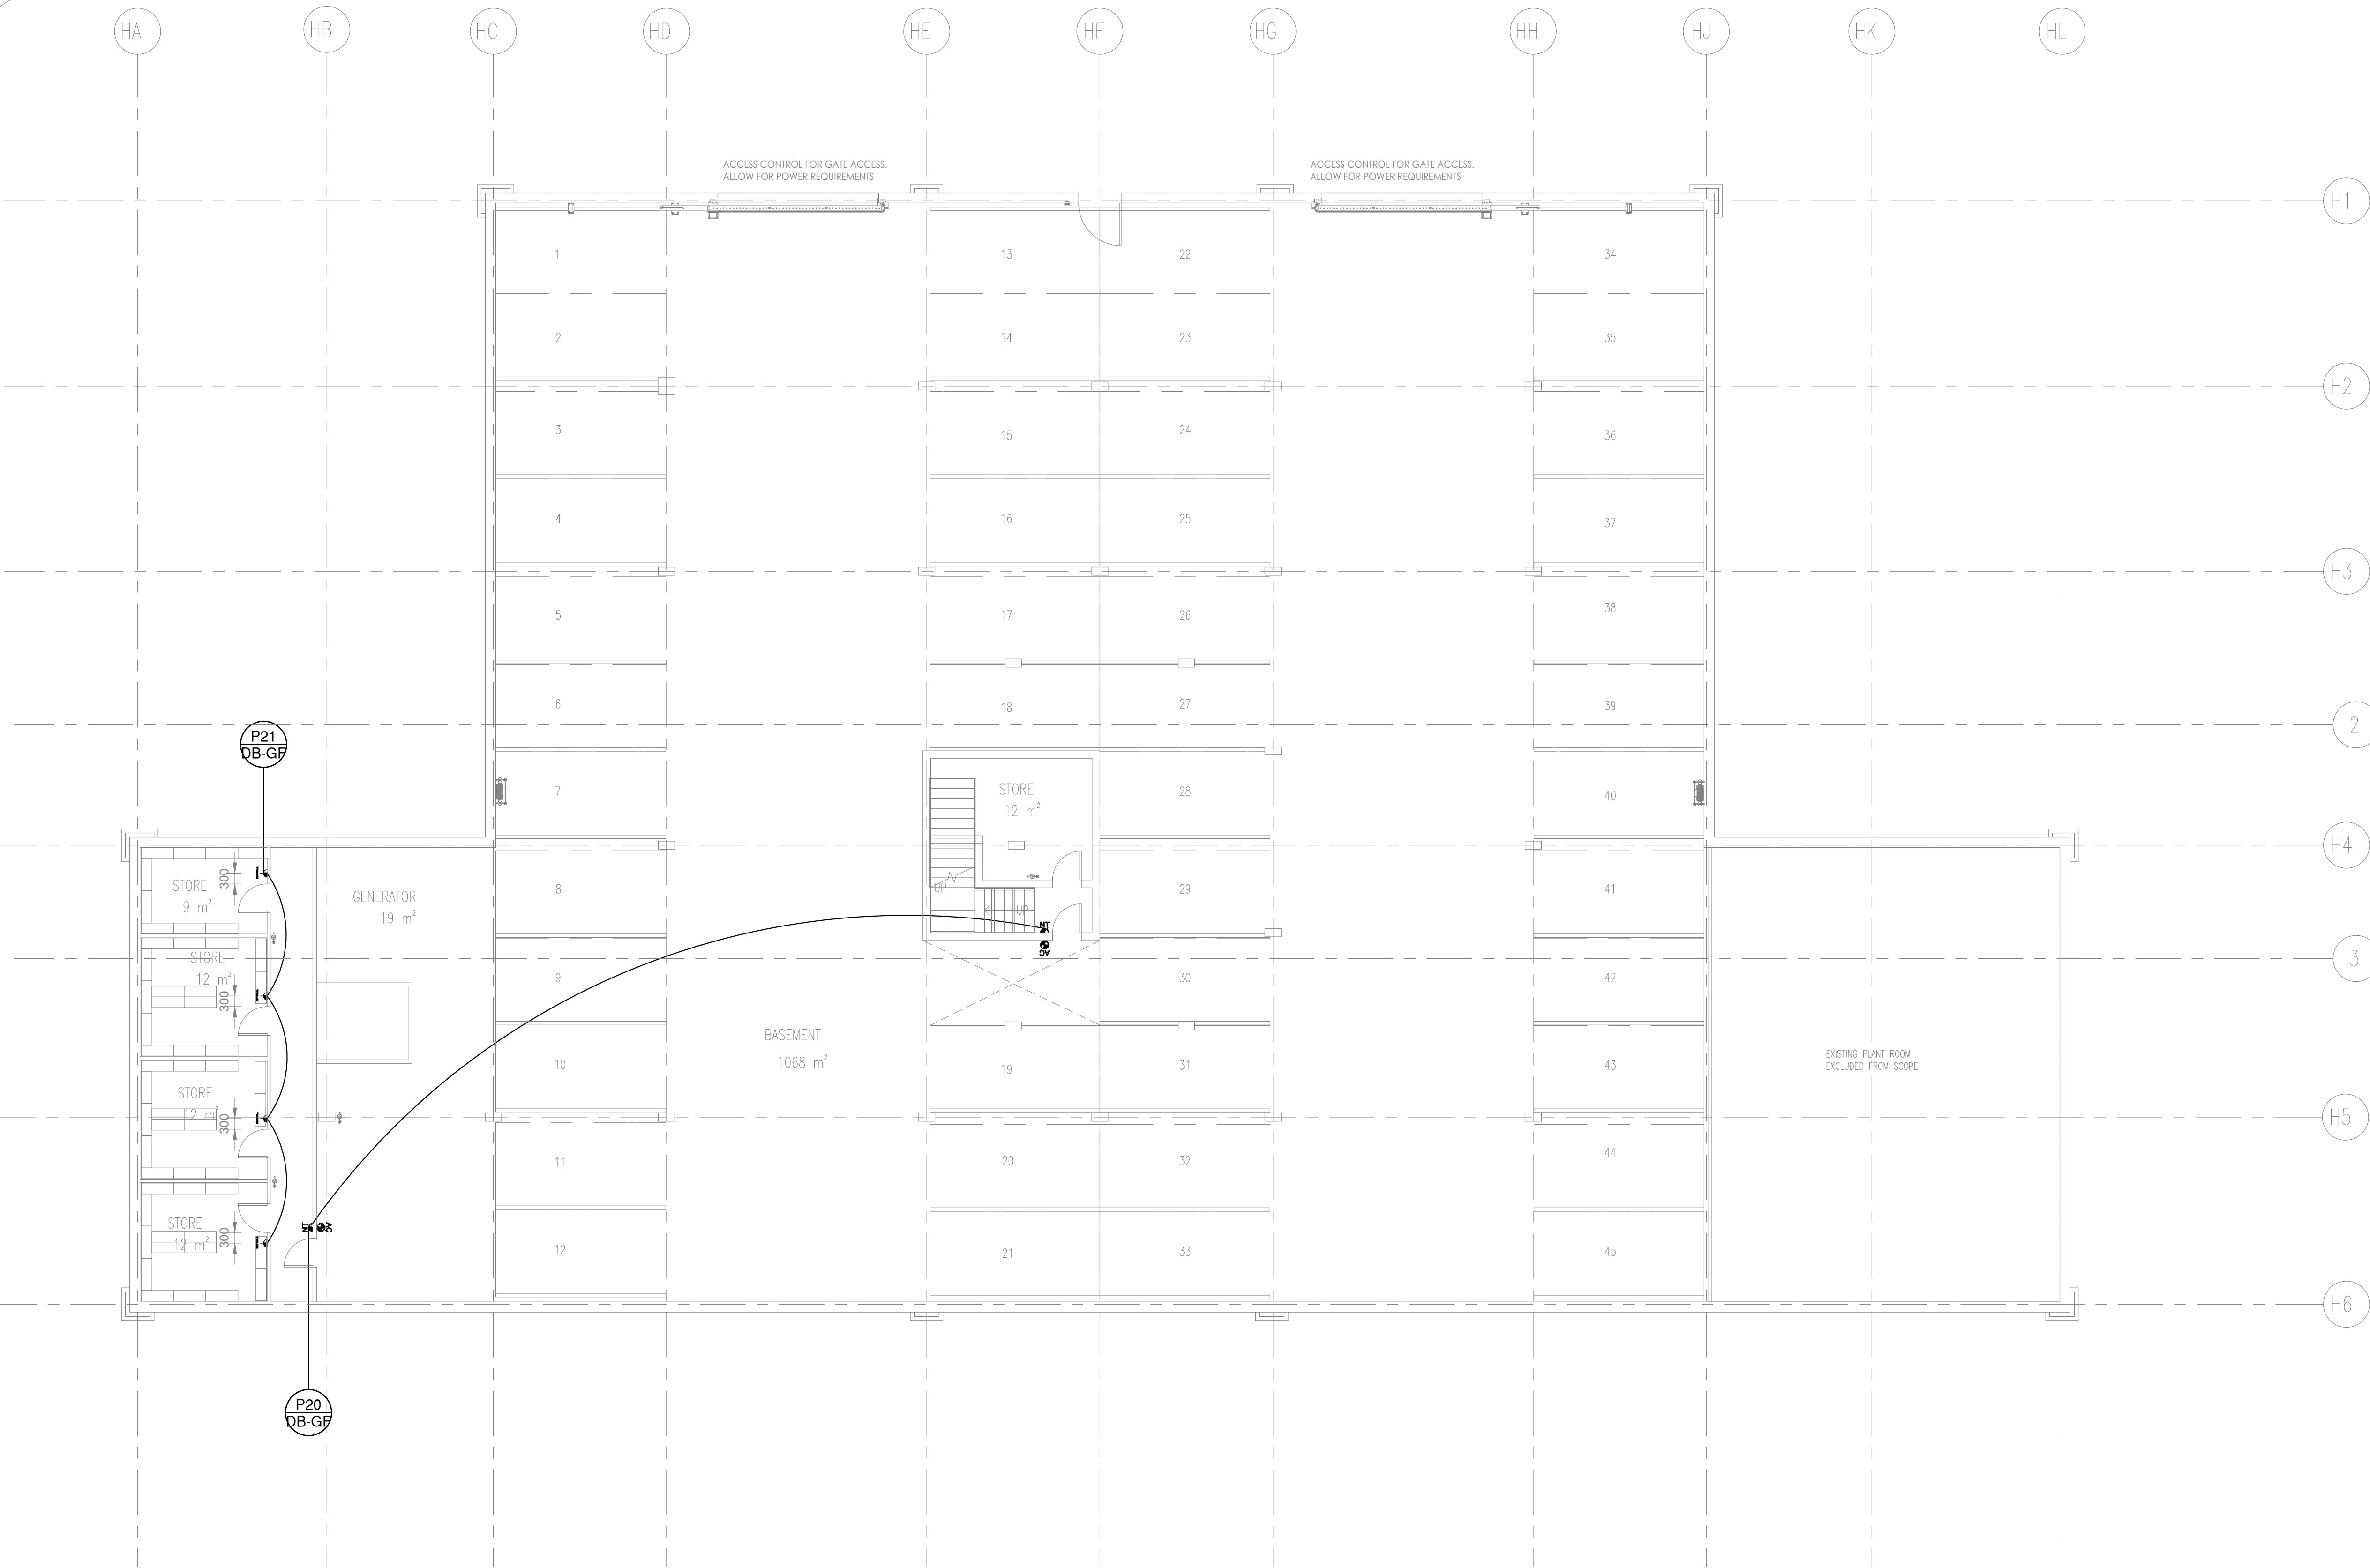

170 PVD SCHEDULE					
Legend	Type Mark	Description	Standard Installation Height	QTY	Image
	EL AC	ACCESS CONTROL POINT- ALLOW FOR DATA (CAT 6A) AND POWER POINT (OLD SA 3 PIN).	1100mm AFFL	7	
	EL D1	SINGLE NORMAL POWER POINT TO BE INSTALLED IN DRYWALL. FITTING: SINGLE SOCKET WITH 4X4 COVERPLATE. COLOUR: BLACK MODULES ON GRAPHITE COVER. MODULE: BLACK MODULE -1 X 16A OLD SA 3 PIN -SWITCHESINGLE NORMAL POWER POINT TO BE INSTALLED IN DRYWALL. FITTING: SINGLE SOCKET WITH 4X4 COVERPLATE. COLOUR: BLACK MODULES ON GRAPHITE COVER. MODULE: BLACK MODULE -1 X 16A OLD SA 3 PIN -SWITCHED	300mm AFFL	4	
	EL NT	NO TOUCH ACCESS CONTROL - ALLOW FOR DATA AND NORMAL POINT	1100mm AFFL	2	

170 PVD SCHEDULE					
Legend	Type Mark	Description	Standard Installation Height	QTY	Image
	SB	EXTERIOR SECURITY BEAMS. SPECIFICATION AS PER ICT AND ELECTRICAL ENGINEER. ALLOW FOR POWER & DATA FOR BEAM POINT. MOUNTING FIXTURE AND HEIGHT AS PER MANUFACTURER.		4	
	SC C	CEILING/SOFFIT FIXED SECURITY CAMERA. SPECIFICATION BY SPECIALIST. ALLOW FOR POWER AND DATA.	CEILING/S OFFIT	8	
	SC W	EXTERIOR WALL FIXED SECURITY CAMERA. SPECIFICATION BY SPECIALIST. ALLOW FOR POWER AND DATA.	WALL MOUNTED . HEIGHT BY SPECIALIST	2	
	SP	CEILING/SOFFIT FIXED PUBLIC ADDRESS SPEAKER. SPECIFICATION BY SPECIALIST. ALLOW FOR POWER AND DATA.		8	

CIRCUITING

A

B

A- CIRCUIT NUMBER
B- DB NAME

ISSUED FOR TENDER

T	ISSUED FOR TENDER	29.08.2025
REV	REVISION DETAILS	DATE
CLIENT		
 MHSC Mine Health and Safety Council		
ARCHITECT		
CONSULTING ENGINEERS		
HENRY FAGAN Consulting Engineers & Project Managers Gauteng Office: Suite 13, Rivonia Gate, 381 Rivonia Boulevard, Rivonia, Sandton, 2191 Tel: 010 500 1486 www.henryfagan.com Western Cape Office: Suite A2, Ground Floor Building 2,Nordic Park 2, 17 Boundary Road, Century City, 7441 Tel: 021 423 0873 www.henryfagan.com		
PROJECT		
MHSC OFFICE BUILDING RENOVATION		
DRAWING TITLE		
BASEMENT POWER LAYOUT		
DRAWN BY	DESIGNED BY	CHECKED BY
B.T	P.M	M.B
SCALE	DATE	SHEET SIZE
1:100	01 JULY 2025	A1
PROJECT - ORIG - ZONE - LEVEL - TYPE - DISC - CLASS - NUMBER - REVISION		
25002 - HF - ZZ - B1 - DR-EE- DD - 1000 - T		