


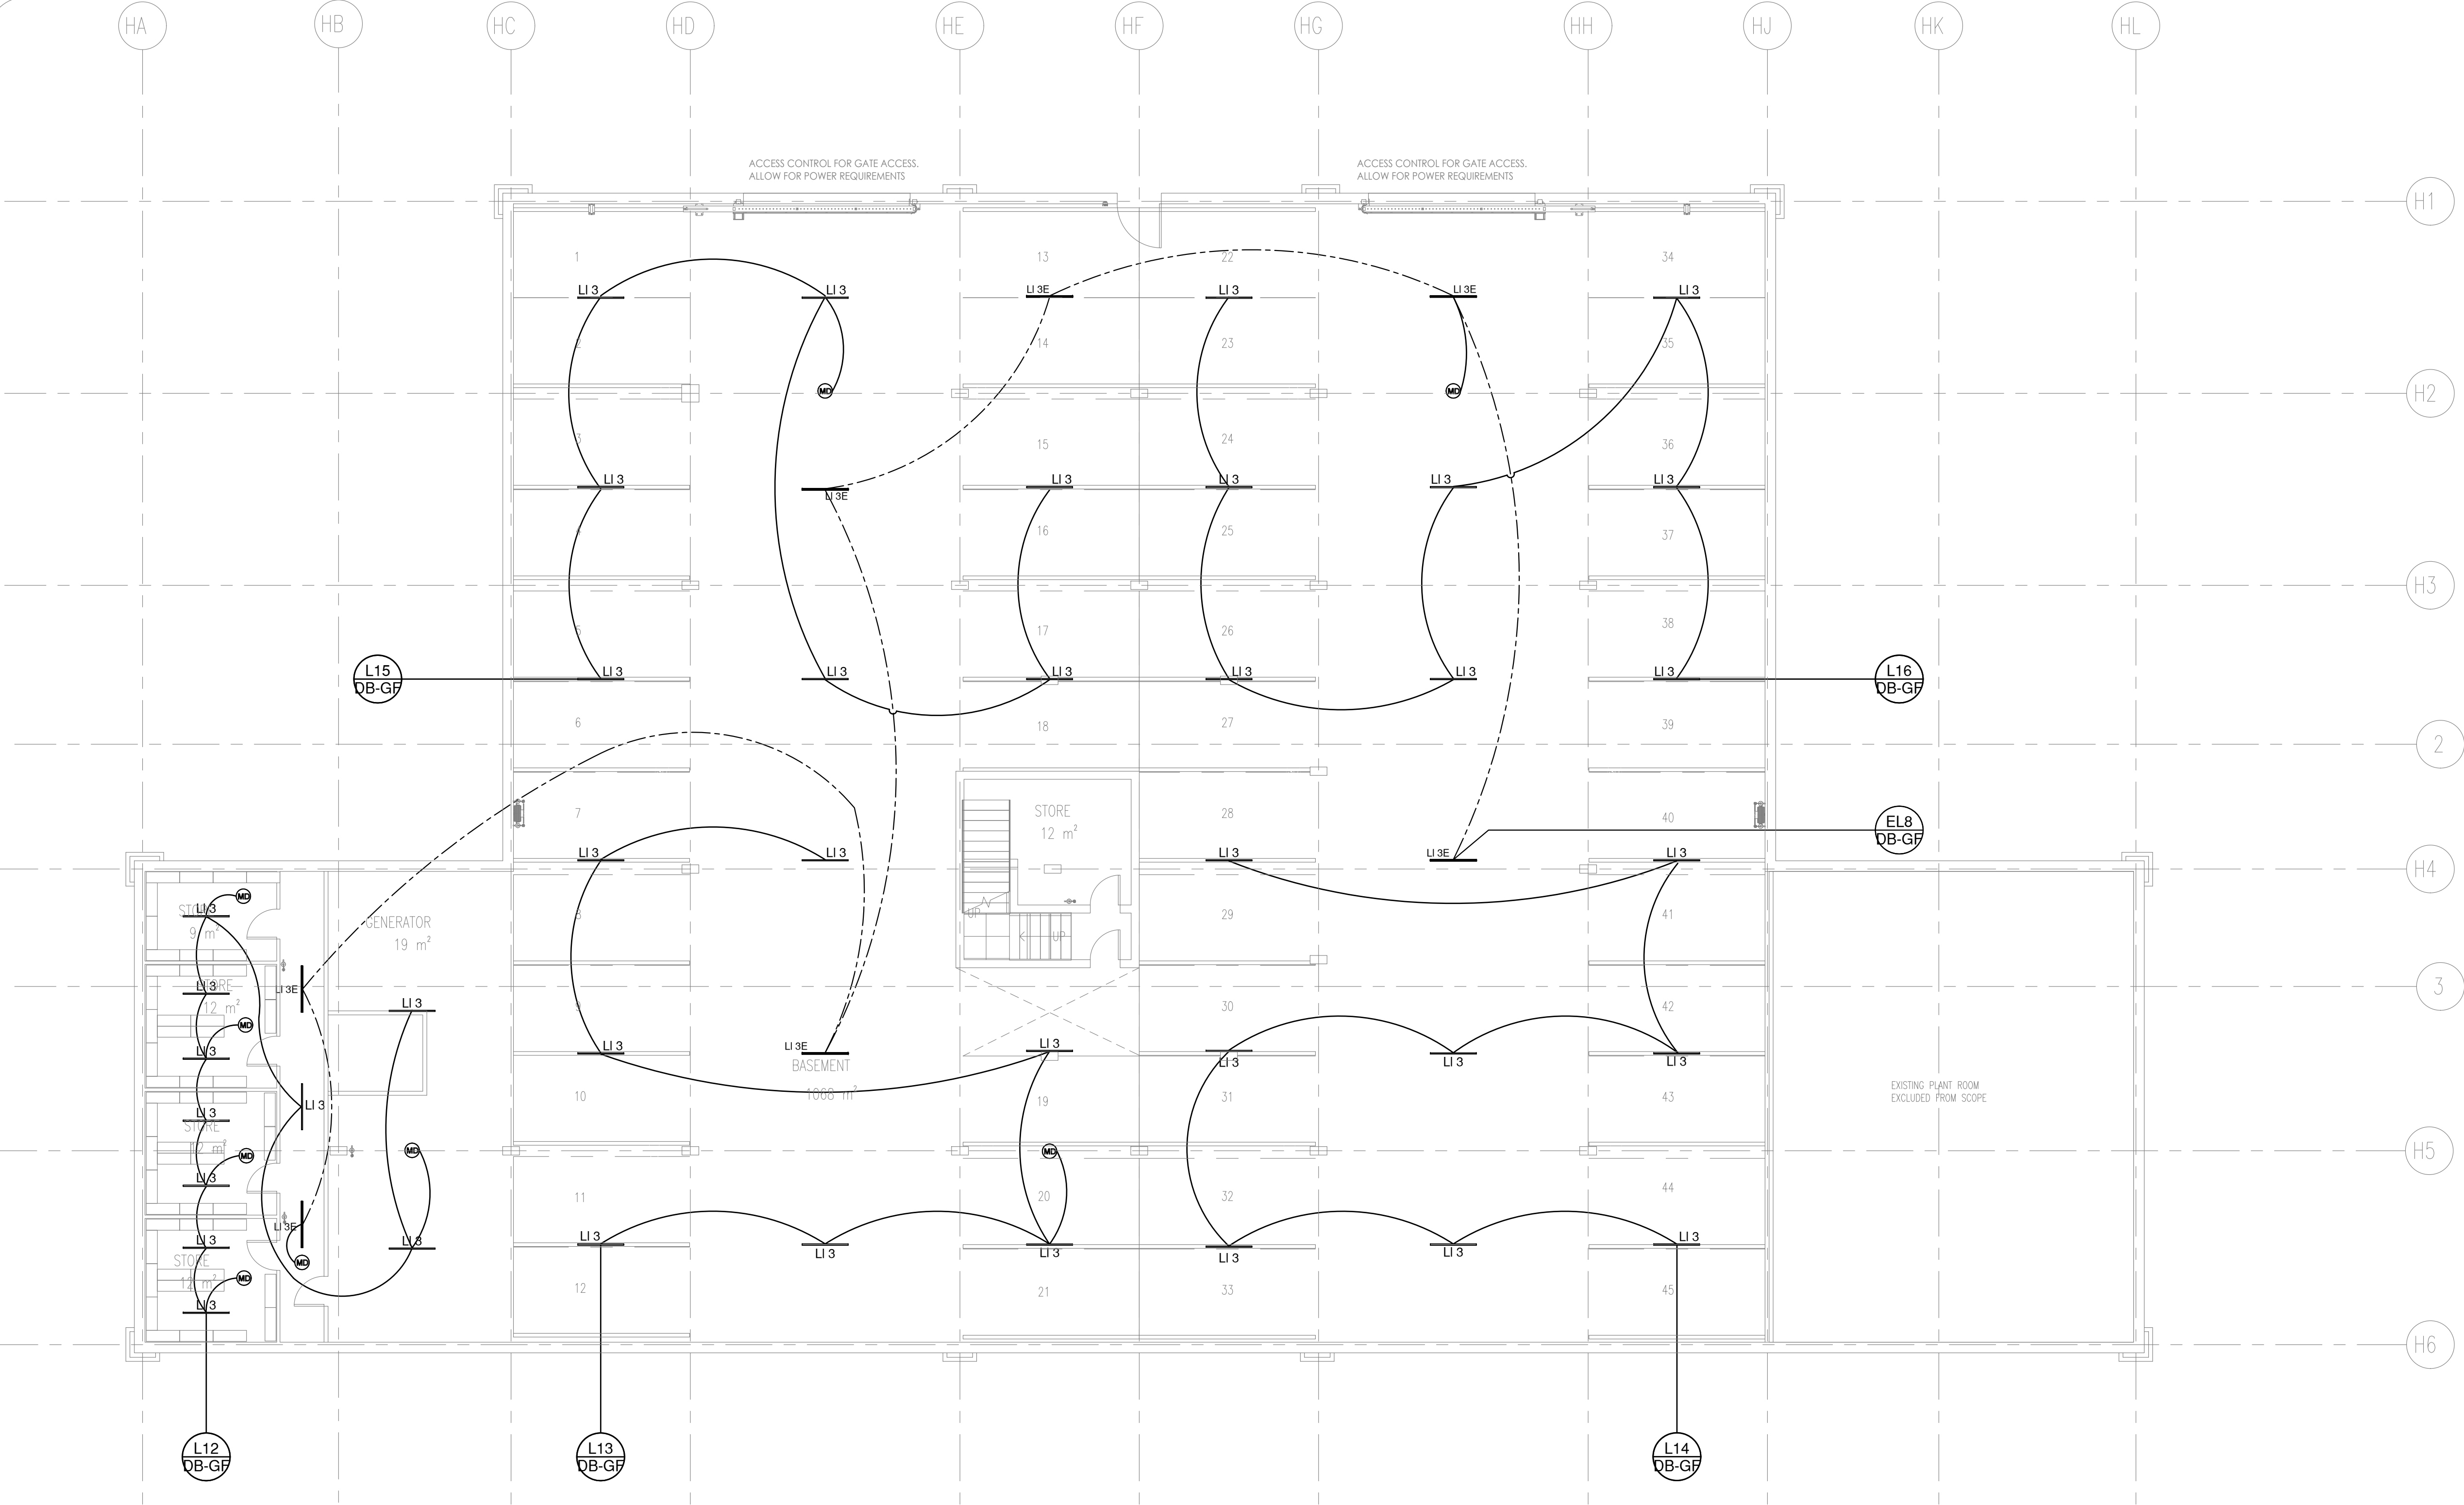

Legend	Type Mark	Description	Mounting Height	Qty	Image
	LI 3	FASTBAT LED BATTEN SIZE: 1230X66X68D mm COLOUR TEMPERATURE: 4000K. BODY MATERIAL: METAL BODY COLOUR: BLACK DIFFUSER: POLYCARBONATE MOUNTING: SURFACE MOUNTED WATTAGE: 40W LUMINOUS FLUX: 5800 lm AVERAGE CRI: 80	SURFACE MOUNTED ON CEILING @2550mm (BASEMENT MOUNTED ON U/S SLAB @2635mm)	42	
	LM 1	PIR RECESSED MOTION DETECTOR SENSOR. SIZE: 73mm DIAMETER X 73mm HEIGHT COLOUR: WHITE IP RATING: 20 RANGE: MAX 6m TIME DELAY: 10s ~7min (ADJUSTABLE) DETECTION RANGE: 360 DEGREE WATTAGE: RATED LOAD 1200W (INCANDESCENT) 300W (ENERGY SAVING) VOLTAGE: 220-240V WARRANTY: 5 YEAR INSTALLATION: RECESSED INTO CEILING CUT OUT: 60mm	SURFACE MOUNTED ON CEILING @2550mm	9	

CIRCUITING

A

B

A- CIRCUIT NUMBER

B- DB NAME

ISSUED FOR TENDER

T	ISSUED FOR TENDER	29.08.2025
REV	REVISION DETAILS	DATE
CLIENT		
 MHSC Mine Health and Safety Council		
ARCHITECT		
CONSULTING ENGINEERS		
HENRY FAGAN Consulting Engineers & Project Managers Gauteng Office: Suite 13, Rivonia Gate, 381 Rivonia Boulevard, Rivonia, Sandton, 2191 Tel: 010 500 1486 www.henryfagan.com Western Cape Office: Suite A2, Ground Floor Building 2,Nordic Park 2, 17 Boundary Road, Century City, 7441 Tel: 021 423 0873 www.henryfagan.com		
PROJECT		
MHSC OFFICE BUILDING RENOVATION		
DRAWING TITLE		
BASEMENT LIGHTING LAYOUT		
DRAWN BY	DESIGNED BY	CHECKED BY
B.T	P.M	M.B
SCALE	DATE	SHEET SIZE
1:100	01 JULY 2025	A1
PROJECT - ORIG - ZONE - LEVEL - TYPE - DISC - CLASS - NUMBER - REVISION		
25002 - HF - ZZ - B1 - DR-EE- DD - 1001 - T		