


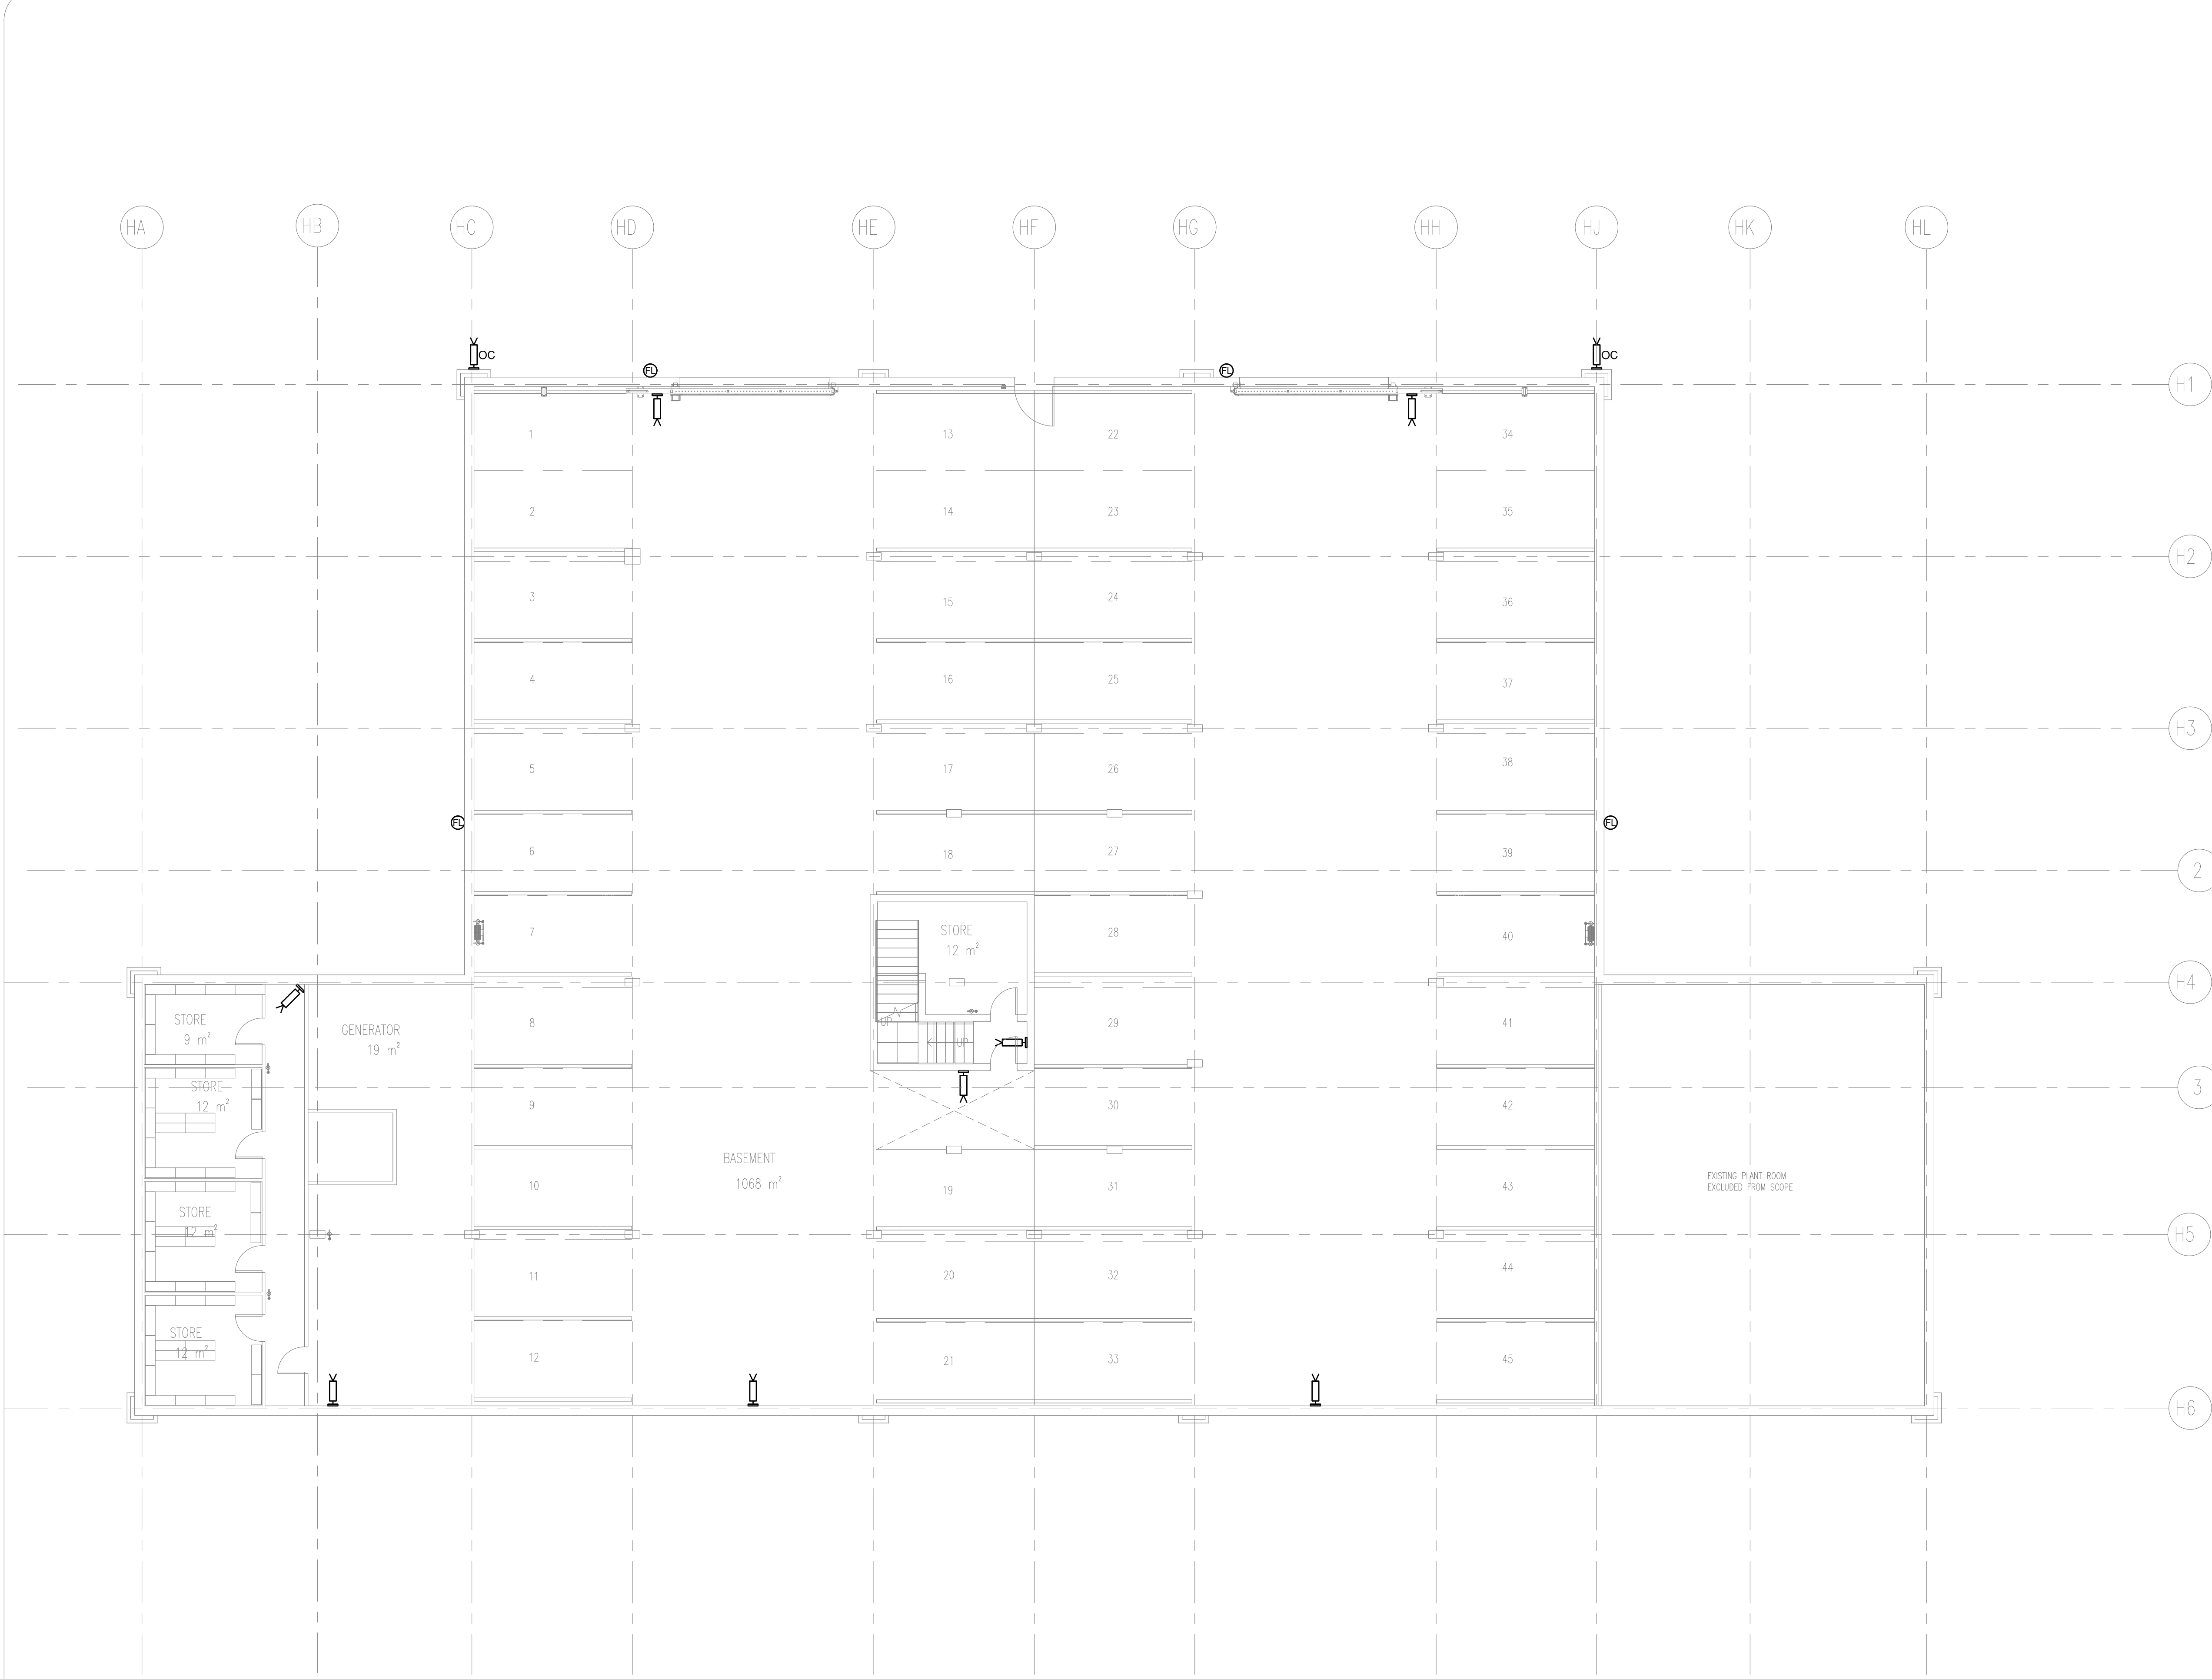

LEGEND		
	OUTSIDE CAMERA	
	INSIDE CAMERA	
	OUTSIDE BEAMS	

ISSUED FOR
TENDER

T	ISSUED FOR TENDER	29.08.2025
REV	REVISION DETAILS	DATE

CLIENT



ARCHITECT

CONSULTING ENGINEERS



HENRY FAGAN
Consulting Engineers & Project Managers

Gauteng Office: Suite 13, Rivonia Gate, 381 Rivonia Boulevard, Rivonia, Sandton, 2191
Tel: 010 500 1486
www.henryfagan.com

Western Cape Office: Suite A2, Ground Floor Building 2,Nordic Park 2, 17 Boundary Road, Century City, 7441
Tel: 021 423 0873
www.henryfagan.com

PROJECT

MHSC OFFICE
BUILDING RENOVATION

DRAWING TITLE

BASEMENT
SECURITY LAYOUT

DRAWN BY	DESIGNED BY	CHECKED BY
B.T	P.M	M.B
SCALE	DATE	SHEET SIZE
1:100	01 JULY 2025	A1

PROJECT	ORIG	ZONE	LEVEL	TYPE	DISC	CLASS	NUMBER	REVISION
25002	HF	ZZ	B1	DR	EE	DD	1004	T