



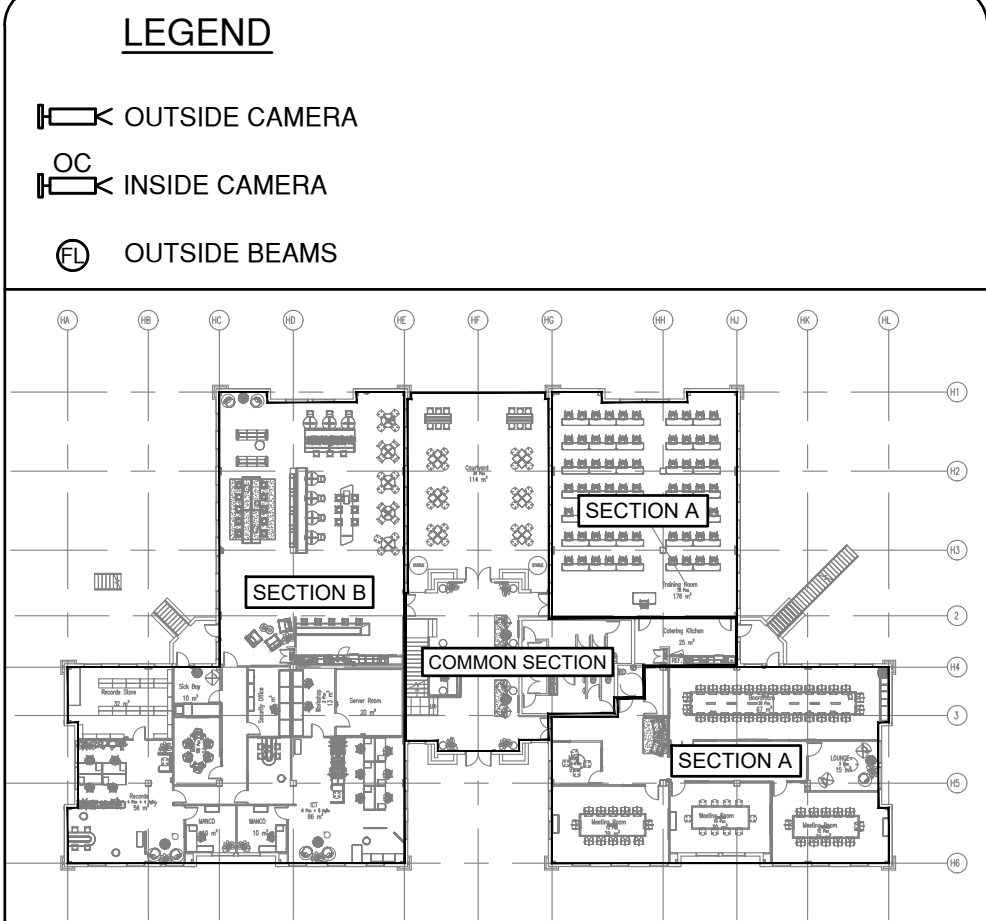

**ISSUED FOR  
TENDER**

|     |                   |            |
|-----|-------------------|------------|
| T   | ISSUED FOR TENDER | 29.08.2025 |
| REV | REVISION DETAILS  | DATE       |

**CLIENT**

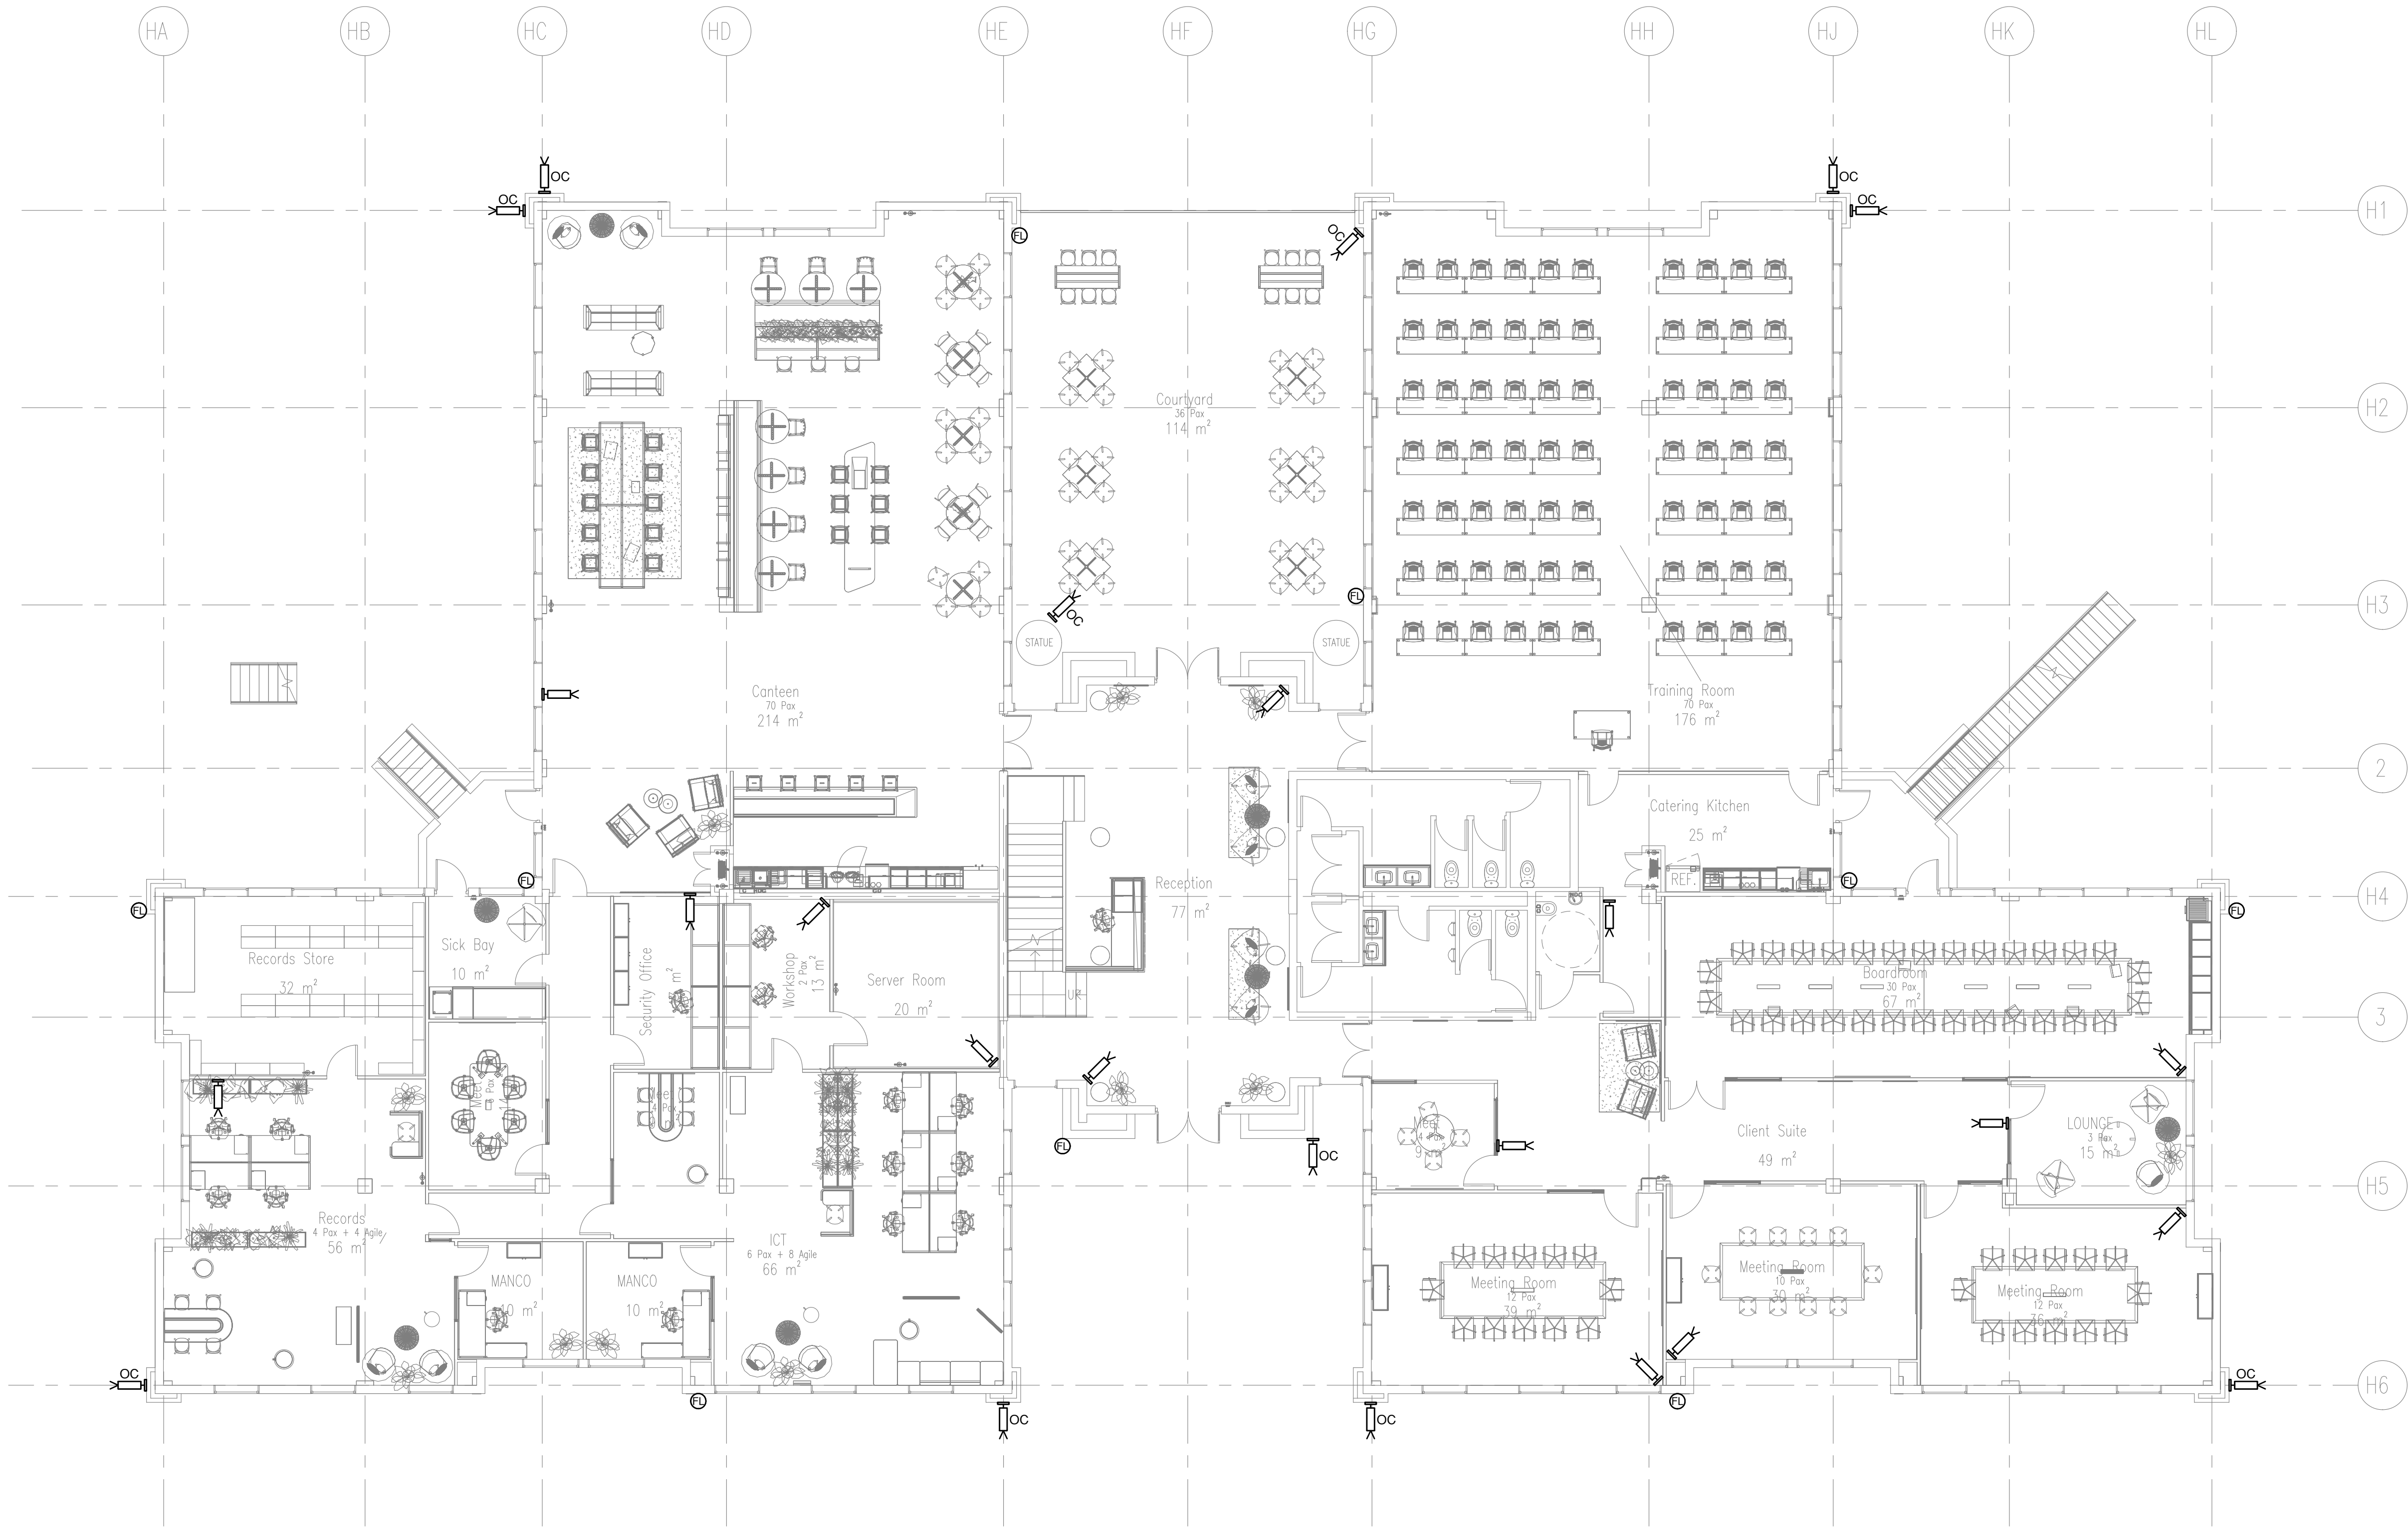

**MHSC**  
Mine Health and Safety Council

**ARCHITECT**

**CONSULTING ENGINEERS**



**HENRY FAGAN**  
Consulting Engineers & Project Managers

**Gauteng Office:** Suite 13, Rivonia Gate, 381 Rivonia Boulevard, Rivonia, Sandton, 2191  
Tel: 010 500 1486  
www.henryfagan.com

**Western Cape Office:** Suite A2, Ground Floor Building 2, Nordic Park 2, 17 Boundary Road, Century City, 7441  
Tel: 021 423 0873  
www.henryfagan.com

**PROJECT**

**MHSC OFFICE  
BUILDING RENOVATION**

**DRAWING TITLE**

**GROUND FLOOR  
SECURITY LAYOUT**

| DRAWN BY | DESIGNED BY  | CHECKED BY |
|----------|--------------|------------|
| B.T      | P.M          | M.B        |
| SCALE    | DATE         | SHEET SIZE |
| 1:100    | 01 JULY 2025 | A1         |

| PROJECT | ORIG | ZONE | LEVEL | TYPE | DISC | CLASS | NUMBER | REVISION           |
|---------|------|------|-------|------|------|-------|--------|--------------------|
| 25002   | -    | HF   | -     | ZZ   | -    | L0    | -      | DR-EE-DD- 1004 - T |