


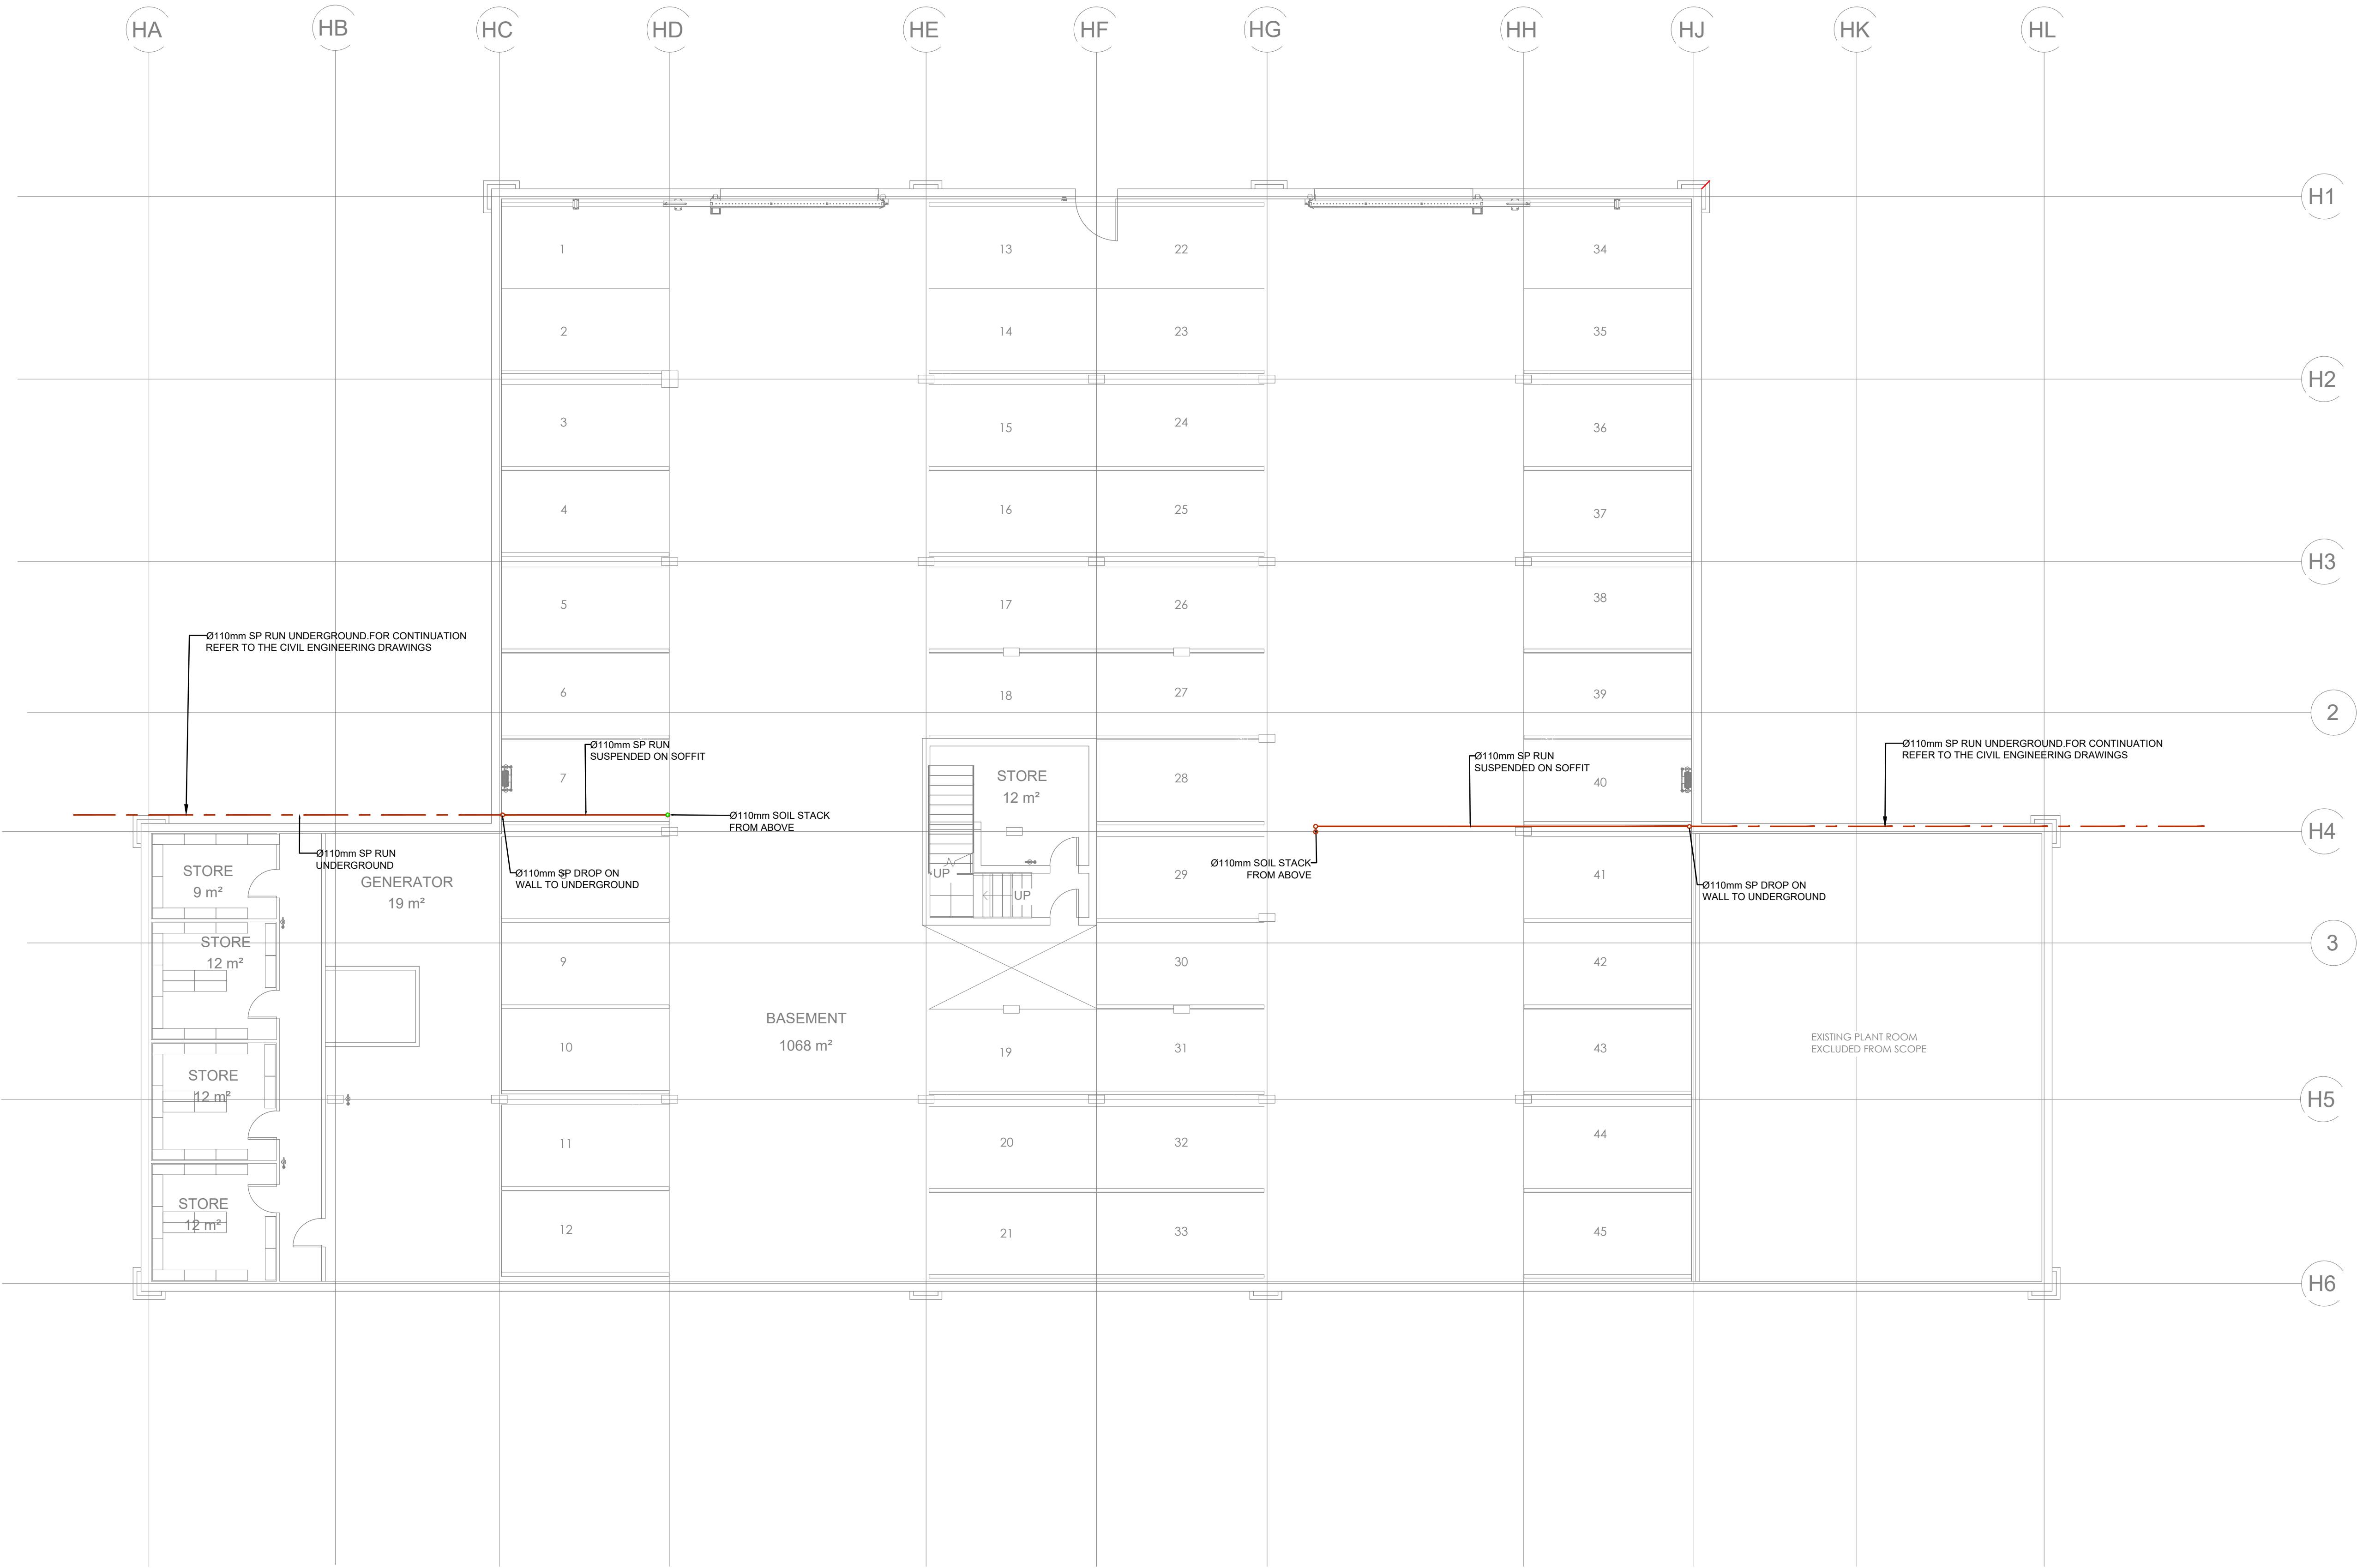

GENERAL NOTES & DISCLAIMER:
ALL WORK TO BE CARRIED OUT IN STRICT ACCORDANCE WITH LOCAL AUTHORITIES REQUIREMENTS, NATIONAL BUILDING REGULATIONS AND RELEVANT SABS/SANS STANDARDS.
CONTRACTORS TO VERIFY ALL LEVELS, HEIGHTS, AND DIMENSIONS ON SITE AND TO CHECK SAME AGAINST DRAWINGS BEFORE PUTTING ANY WORK IN HAND. ANY DISCREPANCIES TO BE BROUGHT TO THE ATTENTION OF WF-P CONSULTING ENGINEERS IMMEDIATELY FOR CLARIFICATION.
CONTRACTORS ARE TO LOCATE AND IDENTIFY EXISTING SERVICES ON SITE AND TO PROTECT THESE FROM DAMAGE THROUGHOUT THE DURATION OF THE WORKS.
ANY ERRORS/ DISCREPANCIES, QUERIES OR OMISSIONS TO BE REPORTED TO WF-P CONSULTING ENGINEERS IMMEDIATELY FOR CLARIFICATION PRIOR TO THE COMMENCEMENT OF ANY WORK.
THIS DRAWING SHALL NOT TO BE SCALED. ONLY FIGURED DIMENSIONS SHALL BE FOLLOWED. ONLY DRAWINGS REFERENCED AS 'FOR CONSTRUCTION' SHALL BE USED FOR CONSTRUCTION PURPOSES.
THIS DRAWING IS THE SOLE PROPERTY OF WF-P CONSULTING ENGINEERS AND MAY NOT BE COPIED OR REPRODUCED IN ANY MANNER WITHOUT THE WRITTEN CONSENT OF HENRY FAGAN CONSULTING ENGINEERS.
-COPYRIGHT-

DRAINAGE LEGEND

	ABOVE GROUND DRAINAGE SOIL PIPE.
	BELOW GROUND DRAINAGE SOIL PIPE.
	CAST-IN DRAINAGE SOIL PIPE.
	SUSPENDED DRAINAGE SOIL PIPE.
	ABOVE GROUND DRAINAGE WASTE PIPE.
	BELOW GROUND DRAINAGE WASTE PIPE.
	CAST-IN DRAINAGE WASTE PIPE.
	SUSPENDED DRAINAGE WASTE PIPE.
	VENT PIPE.
	FLOW DIRECTION
	Ø110 SOIL PIPE CONNECTION TO WC
	Ø56 WASTE PIPE CONNECTION TO SHR
	Ø56 WASTE PIPE CONNECTION TO WHB
	Ø56 WASTE PIPE CONNECTION TO BATH
	Ø56 WASTE PIPE CONNECTION TO SINK WITH RUBBER P-TRAP
	Ø56 WASTE PIPE CONNECTION TO WASHING MACHINE / DISHWASHER Ø56 uPVC CONNECTION WITH RUBBER BUNG, WASTE PIPE 750mm AFFL BELOW COUNTER TOP
	Ø56 WASTE PIPE CONNECTION TO DISHWASHER. Ø56 uPVC CONNECTION WITH RUBBER BUNG, WASTE PIPE 500mm AFFL BELOW COUNTER TOP
	Ø56 WASTE PIPE CONNECTION TO STAINLESS STEEL FD. Ø56 FD FOR HW GENERATION PLANT SAFETY VALVE DRAINAGE
	DISHWASHER/WASHING MACHINE WASTE FLEXIBLE HOSE TO RETICULATE SURFACE MOUNTED IN CUPBOARD AND CONNECT TO APPLIANCE CONNECTION ON TRAP BELOW SINK

T	ISSUED FOR TENDER	27/08/25	T.L
REV	REVISION DETAILS		DATE

CLIENT

MHSC
Mine Health and Safety Council

ARCHITECT

CONSULTING ENGINEERS

HENRY FAGAN
Consulting Engineers & Project Managers

Gauteng Office:

Suite 13, Rivonia Gate, 381 Rivonia Boulevard, Rivonia, Sandton, 2191
Tel: 010 500 1486
www.henryfagan.com

Western Cape Office:

Suite A2, Ground Floor Building 2,Nordic Park 2, 17 Boundary Road, Century City, 7441
Tel: 021 423 0873
www.henryfagan.com

PROJECT

MHS OFFICE
BUILDING RENOVATION

DRAWING TITLE

BASEMENT LEVEL
DRAINAGE LAYOUT

DRAWN BY	DESIGNED BY	CHECKED BY
T.L	T.M	R.R
SCALE	DATE	SHEET SIZE
1:100	01 JULY 2025	A1

PROJECT - ORIG - ZONE - LEVEL - TYPE - DISC - CLASS - NUMBER - REVISION

25002 - HF - ZZ - L0 - DR-WS- DD - 1007 - T

Users\umyhenry.fagan\25002 - MHSC Office Building Renovation Building - Documents\MHSC\Drawings\01 Working Draw\02-MHSC\25002-WS-1000-1007-Basement-Fwg.dwg, 2025/08/26 15:40:31