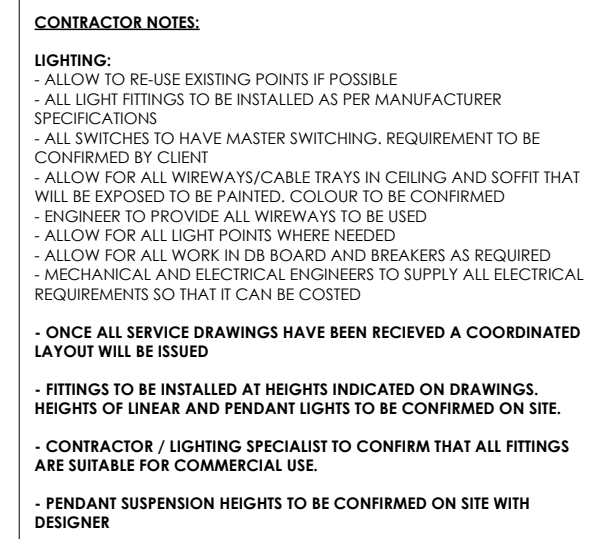




- 1.1 Copyright exists in terms of the Copyright Act, Act No. 98 of 1978
- 1.2 Copyright in these drawings and in the designs which they depict vests in MHSC. Any unauthorised copying of the drawing or use of the design for construction of a building is a criminal offence.
- 1.3 In addition to criminal prosecution, the owner is entitled to sue for damages and claim delivery of the infringing copies.
- 1.4 Copyright infringement includes the sale or distribution of the copy and "COP" includes the adaptation thereof.

2. DRAWINGS

- Show drawings must be approved by the designer prior to the manufacture of any shopping or furniture items.
- Detail drawings must be preferred to arrangement drawings.
- One set of drawings are to be kept on file on site at all times.
- All superseded drawings are to be clearly marked 'SUPERSEDED' and a copy of the superseded drawing is to be handed to the contractor.

- Figured dimensions are to be taken in preference to scaled dimensions.

- The designer is to be notified of any variation by the Project Manager.

5. CONTRACTORS, SUBCONTRACTORS AND ARTISANS

 
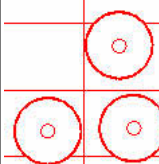
- Contractors must ensure the structural stability of all components of their work and ascertain that the main structure is capable of supporting all loads applied thereto.

6. SHOPFITTED ITEMS

to be approved by the relevant designer and client PRIOR to material order and manufacture.

- All partitions on outside walls are set out from center lines of columns or window mullions. any dimensional errors should be accommodated within these parameters.

TENDER DWG ONLY

Legend	Type Mark	Description	Mounting Height	Qty	Image
	U P3	CYLINDER SHAPED BELLS SMALL TUBE PENDANT OR EQUIVALENT APPROVED SIZE: 65mm DIAMETER 230mm HEIGHT LAMP: GU10 VOLTAGE: 230V WATTAGE: 7.5W COLOUR TEMPERATURE: 4000K BODY: ALUMINIUM COLOUR: BLACK DIFFUSER: ACRYLIC SUSPENSION: 3m CHIP WARRANTY: 1 YEAR	HEIGHT TO U/S OF FITTING: 1800mm	4	
	U P5	ANTIQUE BRASS BASE PENDANT WITH COLOUR GLASS TRIO MULTI-PENDANT CLUSTER FITTING LAMP: 3X E5 FILAMENT CEILING CUP DIAMETER: 350mm WIDTH: 400mm VOLTAGE: 230V WATTAGE: 60W COLOUR TEMPERATURE: 4000K	HEIGHT TO U/S OF FITTING: #1 - 1400mm, #2 - 1550mm, #3 - 1700mm	3	
	LL 1	LINEAR SUSPENDED LED PANEL IP20 LIGHT. EXTRUSION DIMENSIONS: 40X70mm LENGTH: 1200mm COLOUR TEMPERATURE: 4000K LIGHTING DIRECTION: DOWN ONLY BODY MATERIAL: EXTRUDED ALUMINIUM BODY COLOUR: BLACK (POWDER COATED) DIFFUSER: PC MATT OPAL DIFFUSER INSTALLATION: SUSPENDED ON STAINLESS STEEL WIRE AND CABTYRE, ADJUSTABLE WATTAGE: 36W LUMINOUS FLUX: 2880 Lm CRI >80, PF: 0.5	HEIGHT TO U/S OF FITTING: 1800mm (2400mm IN 30 SEATER BOARDROOM)	7	
	LM 1	PIR RECESSED MOTION DETECTOR SENSOR. SIZE: 73mm DIAMETER X 73mm HEIGHT COLOUR: WHITE IP RATING: 20 RANGE: MAX 6m TIME DELAY: 10s ~7min (ADJUSTABLE) DETECTION RANGE: 360 DEGREE WATTAGE: RATED LOAD 1200W (INCANDESCENT) 300W (ENERGY SAVING) VOLTAGE: 220-240V WARRANTY: 5 YEAR INSTALLATION: RECESSED INTO CEILING	SURFACE MOUNTED ON CEILING Ø250mm	58	

APPROVAL SIGNATURES:		A1
APPROVAL DATE:		
DATE DRAWN:	DRAWN BY/CHECKED BY KK	
PROJECT No. MHSC	SCALE 1 : 100	
MHSC OFFICE RENOVATION TUSCANY OFFICE PARK		
DRAWING TITLE: UPPER LEVELS LIGHTING LAYOUT		
DWG No. 240.01	L	
ISSUED FOR: TENDER		