


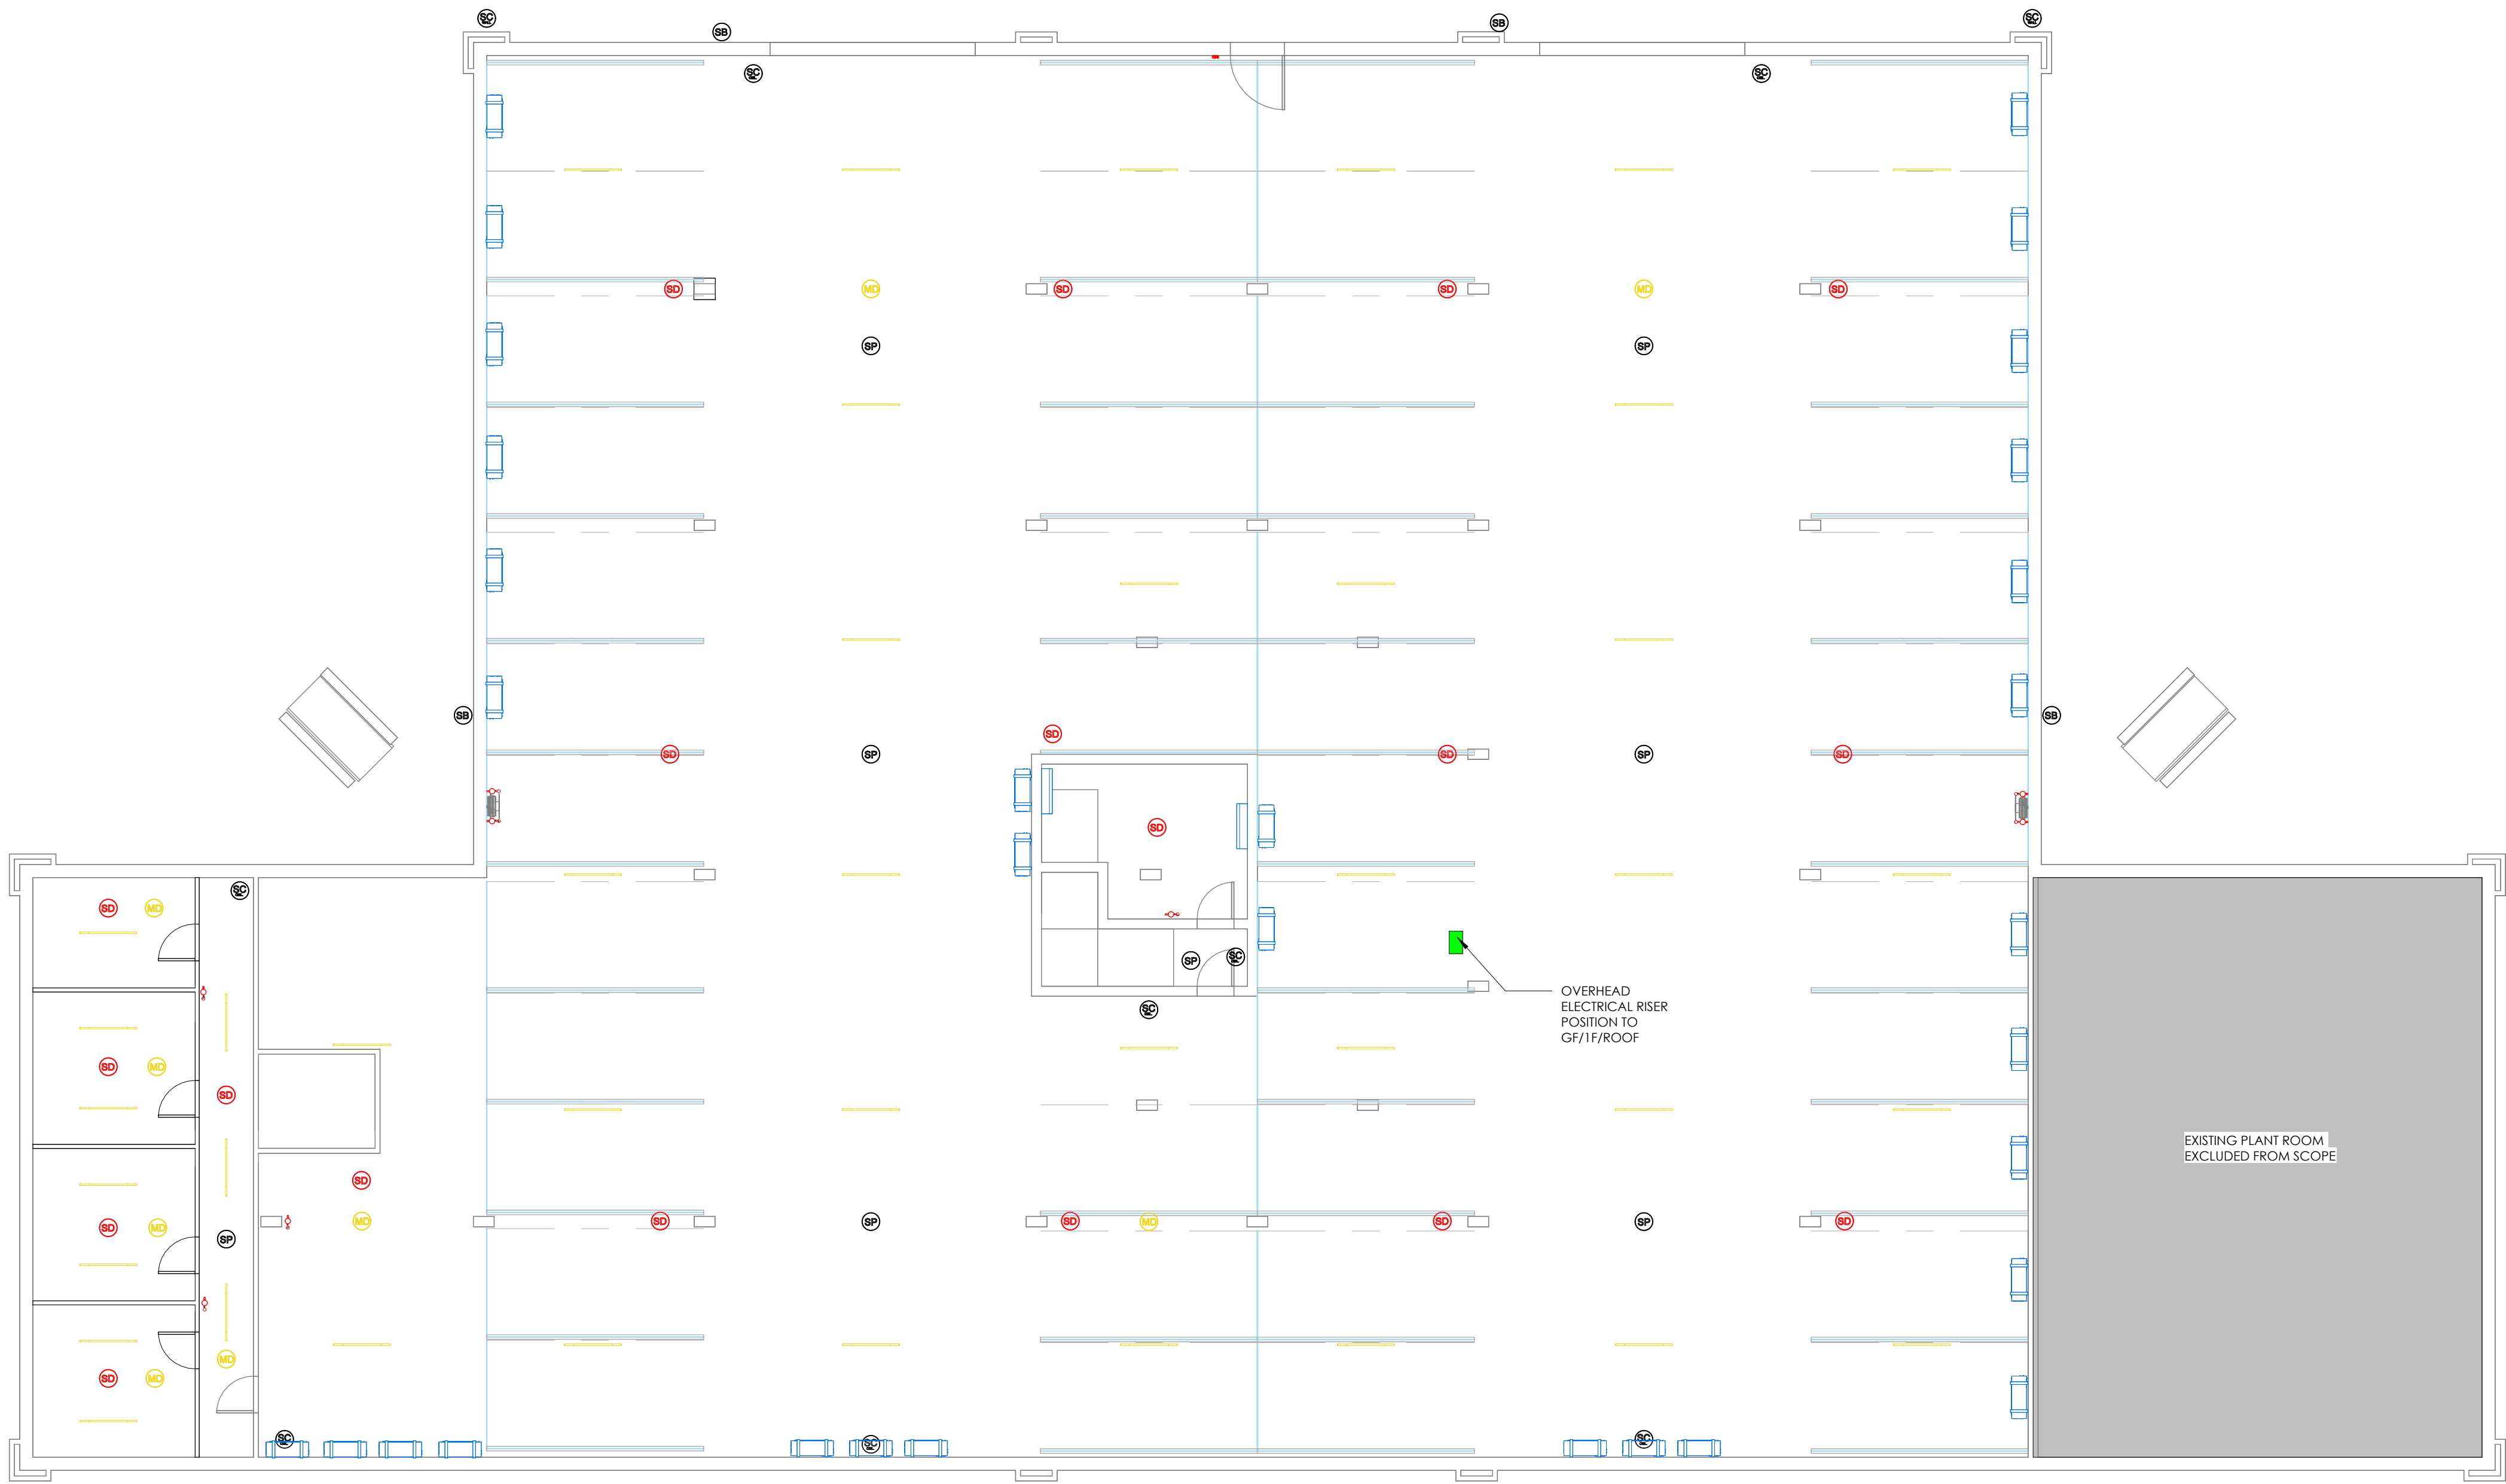

1 250.B BASEMENT COORDINATION LAYOUT
1 : 100

250 FIRE PROTECTION				
Legend	Type Mark	Description	Count	
	FEX	FIRE EXTINGUISHER TO FIRE ENGINEER SPECIFICATION	8	
	FHR	FIRE HOSE REEL TO FIRE ENGINEER SPECIFICATION	2	

250 FIRE ALARM DEVICES				
Legend	Type Mark	Description	Count	
	BGR	BREAK GLASS UNIT TO ENGINEER SPECIFICATION, TO BE MOUNTED ON HAND SIDE OF DOOR.	1	
	SD	SMOKE DETECTION TO ENGINEER SPECIFICATION	19	

250 HVAC SCHEDULE				
Legend	Type Mark	Description	Count	
	CON	HVAC CONDENSOR TO BE WALL MOUNTED.	31	
	SPL	WALL MOUNTED SPLIT AIRCONDITIONING UNIT	2	

SPECIFICATIONS OF FITTINGS AND DUCTWORK TO MECHANICAL ENGINEER SPECIFICATION.

LIGHTING SPECIFICATIONS AS PER 240 SERIES DRAWINGS AND SPECIFICATION DOCUMENTS. LIGHTING ENGINEER TO ISSUE ALL CABLE WAYS.

CONTRACTOR NOTES:

CONSTRUCTION:

- ELECTRICIAN TO CONFIRM IF ANY TRAPDOORS ARE REQUIRED IN FLUSHPLASTER CEILING. POSITION TO BE CONFIRMED WITH DESIGNER PRIOR TO COMMENCEMENT OF WORKS.
- ALL SERVICES AND TRACES THAT REQUIRE WORK IN THE CEILINGS MUST BE COMPLETE BEFORE CLOSING OF CEILINGS TAKE PLACE
- ALLOW TO RHINOLITE BULKHEADS AND FLUSHPLASTER CEILINGS
- ANY CUT OUTS IN FLUSHPLASTER FOR SERVICES MUST BE CONFIRMED BY PROFESSIONAL BEFORE ANY CEILING IS CUT
- ELECTRICIAN TO CONFIRM WHO WILL DO DOWNLIGHT CUT OUTS IN CEILINGS

PAINT

- ALLOW TO PAINT FLUSHPLASTER CEILINGS

HVAC:

- MECHANICAL ENGINEER TO ADVISE ON SYSTEMS REQUIRED AND PLACEMENT THEREOF. ONCE MARKED DRAWING OF HVAC HAS BEEN RECEIVED A COORDINATED LAYOUT WILL BE SENT
- CONFIRM WITH ELECTRICIAN ANY POWER REQUIREMENTS
- EXISTING AC UNIT TO BE REMOVED OR REPOSITIONED TO SUIT NEW LAYOUT.

FIRE:

- SMOKE DETECTION TO BE ALLOCATED AS PER FIRE CONSULTANT REQUIREMENTS. POSITION AS PER COORDINATED DRAWING.
- SPRINKLERS TO BE REMOVED OR RELOCATED AS INDICATED ON COORDINATION LAYOUT. TO BE CONFIRMED BY FIRE ENGINEER.
- SMOKE DETECTION TO BE MADE SAFE DURING DEMOLITION STAGE.

ELECTRICAL & LIGHTING:

- STRIP OUT EXISTING PLUG POINTS IN PLENUM THAT ARE TO BE DEMOLISHED AND MAKE SAFE
- ALLOW TO REMOVE EXISTING AIRCON POINTS WHERE UNITS ARE TO BE REMOVED OR RELOCATED.
- ALLOW TO REMOVE OR RELOCATE EXISTING LIGHT FITTINGS AND LIGHT SWITCHES AS INDICATED ON LIGHTING/PVD LAYOUT.
- ALLOW TO TERMINATE AND CLOSE UP ALL PLUG POINTS / FLOOR BOXES AS INDICATED.

ACCESS CONTROL/ALARMS:

- EXISTING ACCESS CONTROL, ALARM SYSTEMS, AND SPECIALISED ENTRIES TO REMAIN, UNLESS OTHERWISE STATED.

GENERAL NOTES:

- * CONTRACTORS TO RAISE ANY ISSUES/QUERIES DURING THIS TIME.
- * SITE MEASUREMENTS ARE IMPORTANT. CONTRACTORS TO CHECK ALL DIMENSIONS ON SITE PRIOR TO ANY COMMENCEMENT OF WORKS.
- * ALL EXISTING FINISHES THAT ARE ON EXISTING WALLS ARE TO REMAIN UNLESS OTHERWISE STATED.
- IE. EXISTING SKIRTINGS, DOORS, LIGHT SWITCHES, PLUG POINTS ETC.

GENERAL NOTES

1. COPYRIGHT

1.1 Copyright exists in terms of the Copyright Act, Act No. 98 of 1978
1.2 Copyright in these drawings and in the designs which they depict vests in MHSC. Any unauthorised copying of the drawing or use of the design constitutes infringement of copyright and is a criminal offence.
1.3 In addition to criminal prosecution, the owner is entitled to sue for damages and claim delivery of the infringing copies.
1.4 Copyright infringement includes the sale or distribution of the copy and 'COPY' includes the adaptation thereof.

2. DRAWINGS

- Shop drawings must be approved by the designer prior to the manufacture of any shopfitting or furniture items.
- Detail drawings must be preferred to arrangement drawings.
- One set of drawings are to be kept on site at all times.
- All superseded drawings are to be clearly marked 'SUPERSEDED' and a copy of the superseded drawing is to be handed to the contractor.

3. DIMENSIONS

- Contractors and subcontractors are to check and verify dimensions and detail levels before commencing with work.
- Figured dimensions are to be taken in preference to scaled dimensions.

4. VARIATIONS AND AMENDMENTS

- The designer is to be notified of any variation by the Project Manager.

- All relevant detail, levels and dimensions of any work done, must be checked on site by all contractors. Any discrepancies are to be reported to the relevant designer at Turnkey Interiors' immediately

5. CONTRACTORS, SUBCONTRACTORS AND ARTISANS

- Contractors must ensure the structural stability of all components of their work, and ascertain that the main structure is capable of supporting all loads applied thereto.
- All electrical and drainage work is to be executed by the registered artisans.

6. SHOPFITTED ITEMS

Shopfitted items are to be measured on site and shop drawings are to be approved by the relevant designer and client PRIOR to material order and manufacture.

7. PARTITIONS

- All partitions on outside walls are set out from center lines of columns or window mullions. any dimensional errors should be accommodated within these parameters.
- All partitions to be rodent proofed and have a minimum of 30 minute fire rating

ISSUED
2025.09.02
TENDER DWG ONLY

REVISION SCHEDULE		
NO	DESCRIPTION	DATE
A	ISSUED FOR COORDINATION	2025.08.13
B	REVISED FOR COORDINATION	2025.08.18
C	ISSUED FOR TENDER	2025.09.02

REFER TO ALL RELEVANT LAYOUTS BEFORE COSTING AND CONSTRUCTION



MHSC
Mine Health and Safety Council

APPROVAL SIGNATURES:		A1
APPROVAL DATE:		
DATE DRAWN:	DRAWN BY/CHECKED BY KK	
PROJECT No. MHSC	SCALE 1 : 100	
MHSC OFFICE RENOVATION TUSCANY OFFICE PARK		
DRAWING TITLE: BASEMENT COORDINATION LAYOUT		
DWG No.	250.B	C
ISSUED FOR: TENDER		